
 


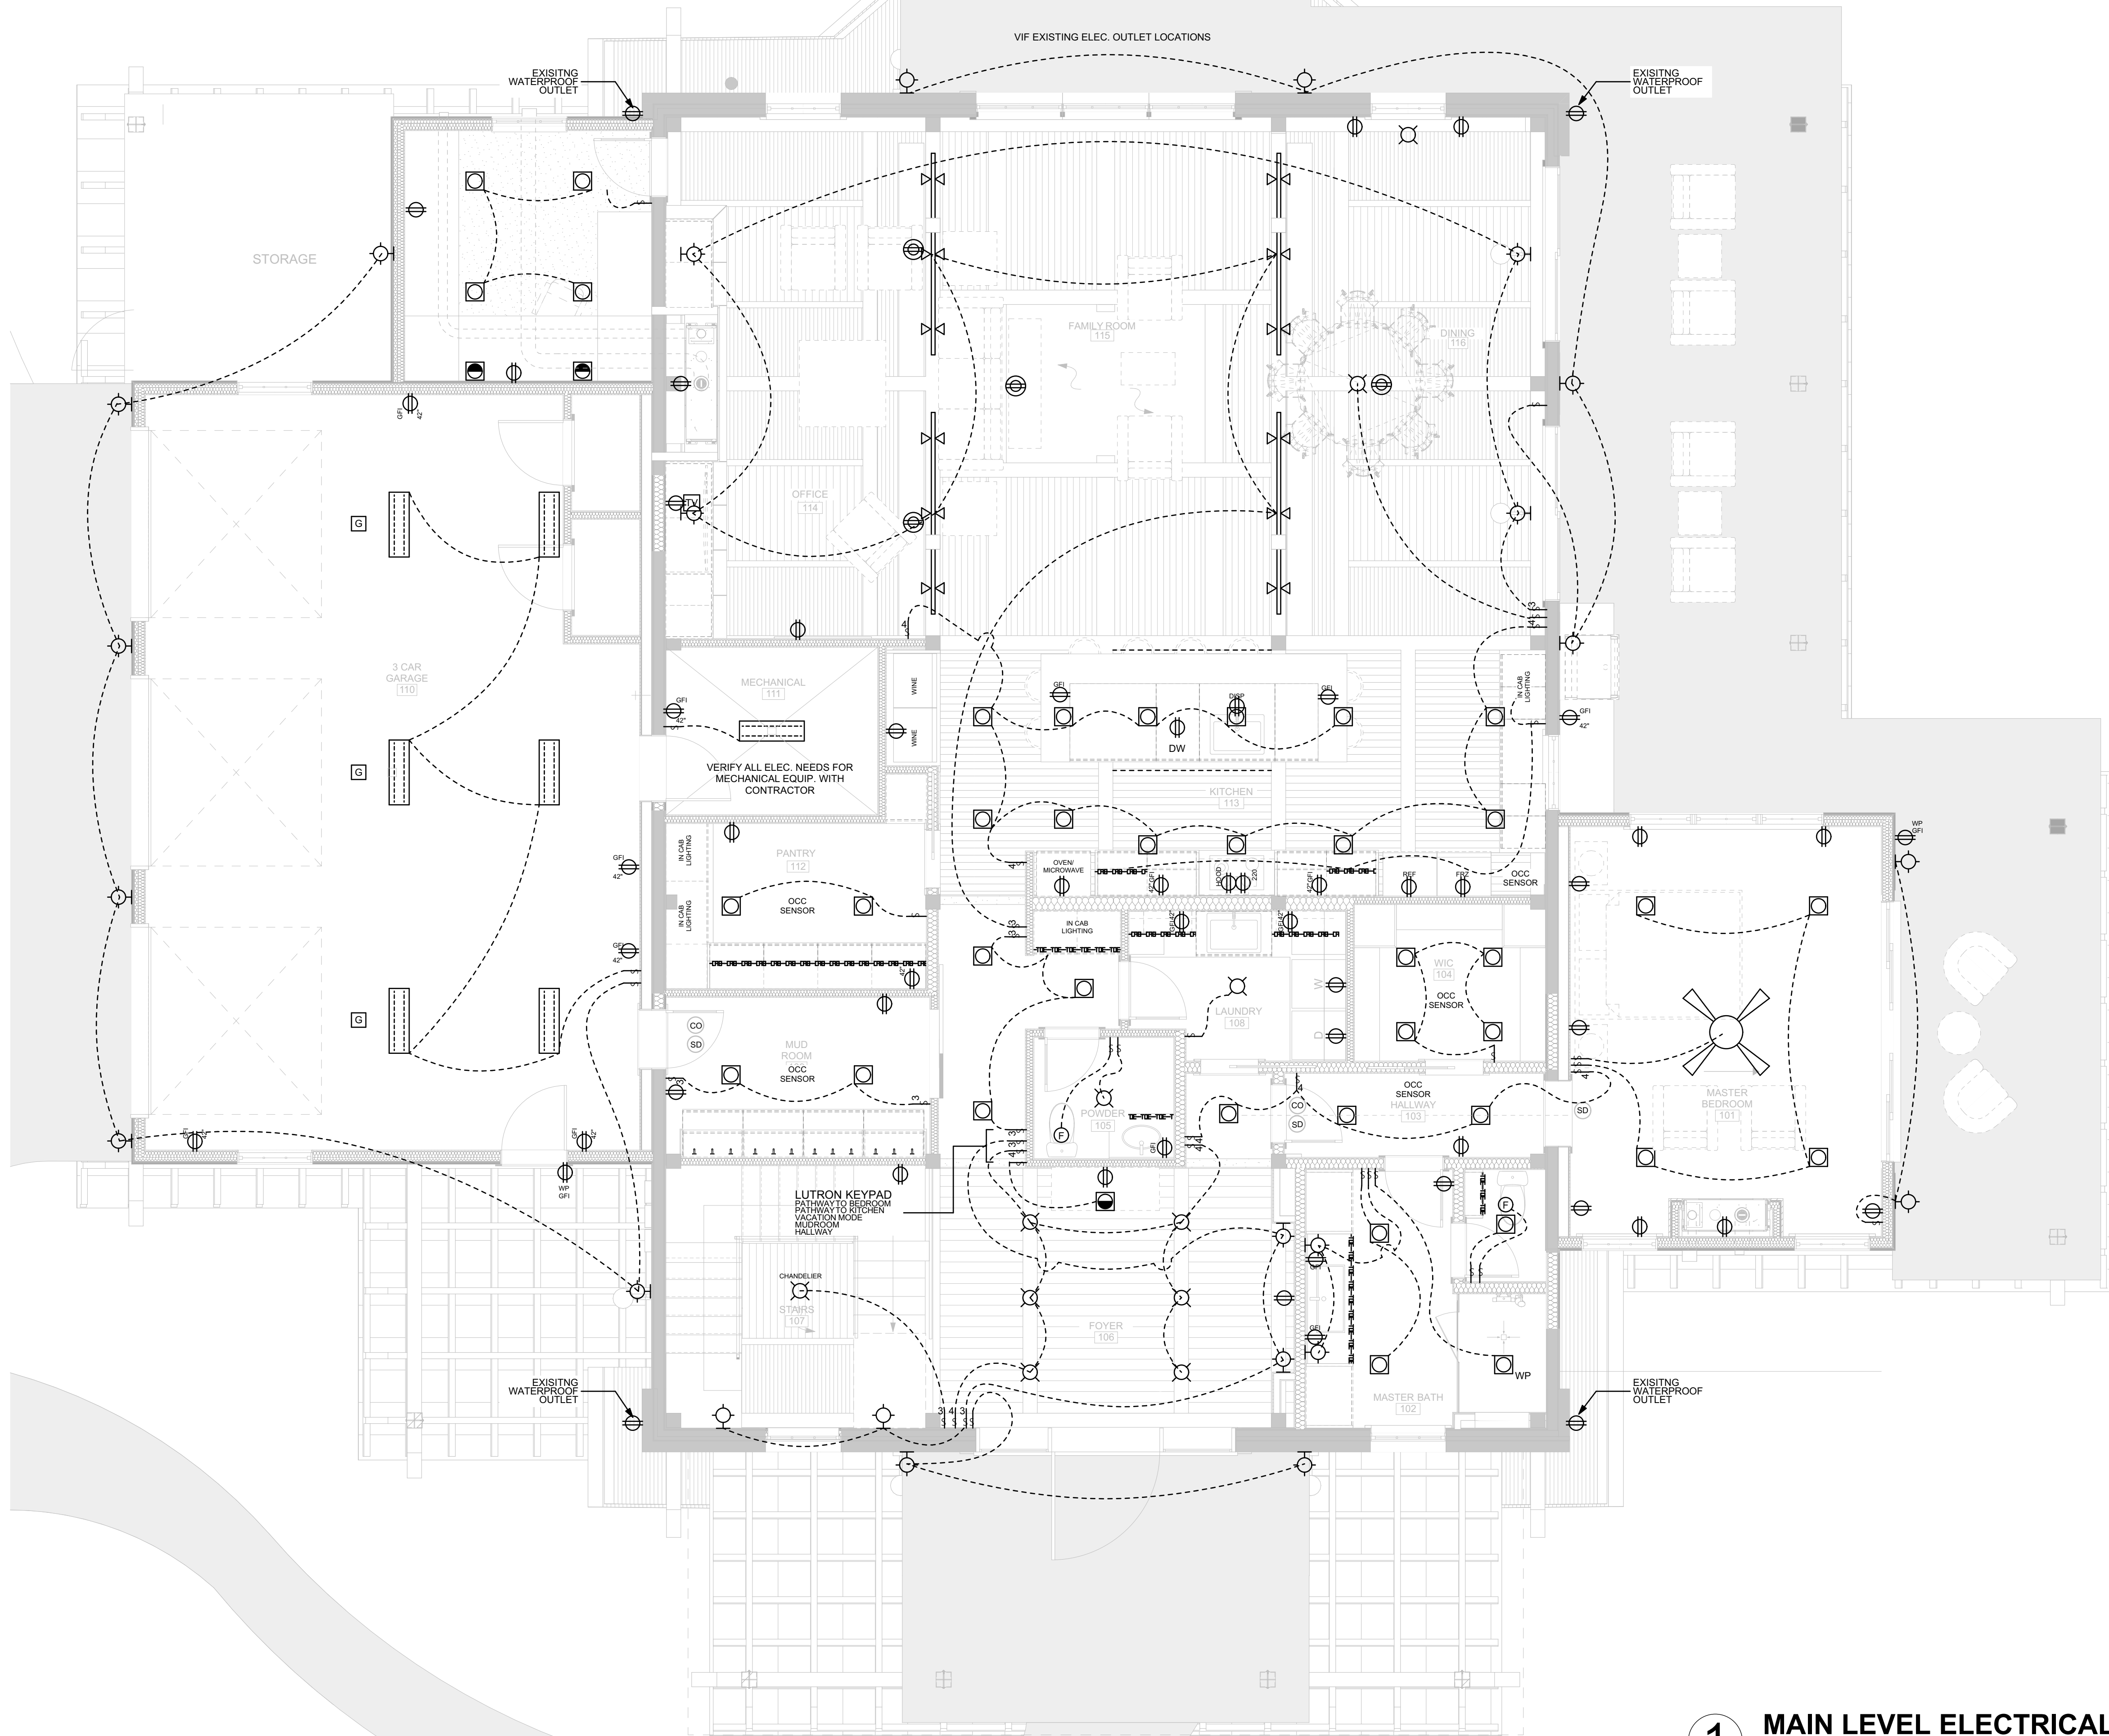

1 MAIN LEVEL ELECTRICAL PLAN

SCALE: 1/4" = 1'-0"





ELECTRICAL SYMBOLS KEY

- SURFACE MOUNTED MONOPOINT
- SURFACE MOUNTED OR HANGING FIXTURE
- RECESSED CAN FIXTURE
- RECESSED CAN FIXTURE (WALL WASH)
- WALL MOUNTED FIXTURE
- SPOT FIXTURE
- FLUORESCENT SURFACE MOUNTED FIXTURE
- UNDER CAB LED FIXTURE
- TOE KICK LED FIXTURE
- TRACK LIGHT
- LANDSCAPE LIGHT
- DOUBLE FLOOD LIGHT
- DUPLEX RECEPTACLE OUTLET
- WATERPROOF DUPLEX RECEPTACLE OUTLET
- DUPLEX RECEPTACLE OUTLET SPLIT WIRED
- QUADRUPLUX RECEPTACLE OUTLET
- DUPLEX RECEPTACLE OUTLET FLOOR MOUNTED
- 220 VOLT OUTLET
- TELEPHONE OUTLET
- CABLE TELEVISION OUTLET
- CEILING EXHAUST FAN
- GARAGE DOOR OPENER
- SINGLE SWITCH
- THREE-WAY SWITCH
- FOUR-WAY SWITCH
- DIMMER SWITCH
- JUNCTION BOX
- SMOKE & CARBON MONOXIDE DETECTOR
- CEILING FAN
- EXTERIOR SPACE HEATER
- EXT. STAIR LIGHT

NOTE: ALL FIXTURE AND OUTLET LOCATIONS SUBJECT TO CODE COMPLIANCE AND STRUCTURAL FRAMING MEMBER LOCATIONS

KELLY & STONE
ARCHITECTS
ARCHITECTURE PLANNING INTERIORS

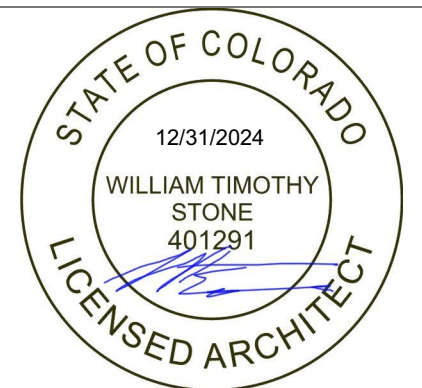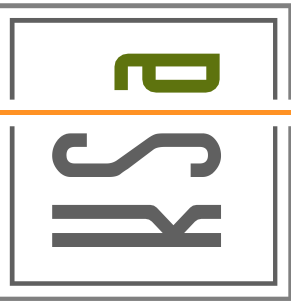

REVIEWED
FOR CODE
COMPLIANCE

10/14/2024

LARSON BARN REMODEL
32130 WILD GOOSE LANE
STEAMBOAT SPRINGS, CO

CD ISSUE SET

ISSUE HISTORY

ID	NAME	DATE
01	PERMIT SET	07/25/2024
02	PRICING SET	07/29/2024
03	CD SET	09/27/2024
04	DELTA 01	10/07/2024

PROJECT NUMBER: S_2401


SHEET TITLE:
MAIN LEVEL ELECTRICAL
PLAN

SHEET NUMBER:


E.1

© COPYRIGHT KS|a INC.

PLEASE RECYCLE

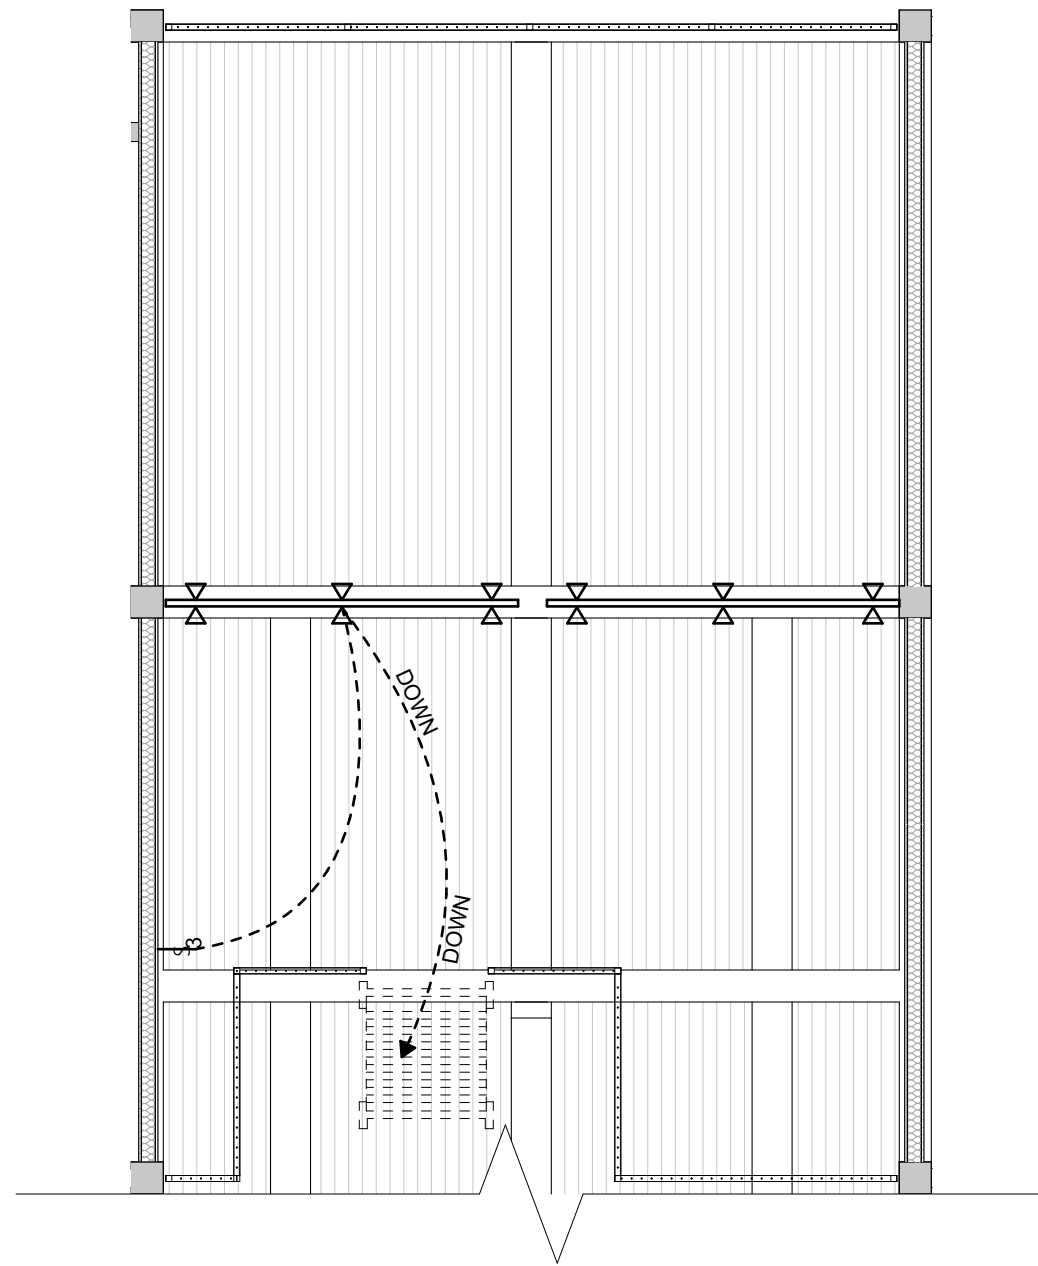

2 STORAGE LEVEL ELECTRICAL PLAN
SCALE: 1/4" = 1'-0"

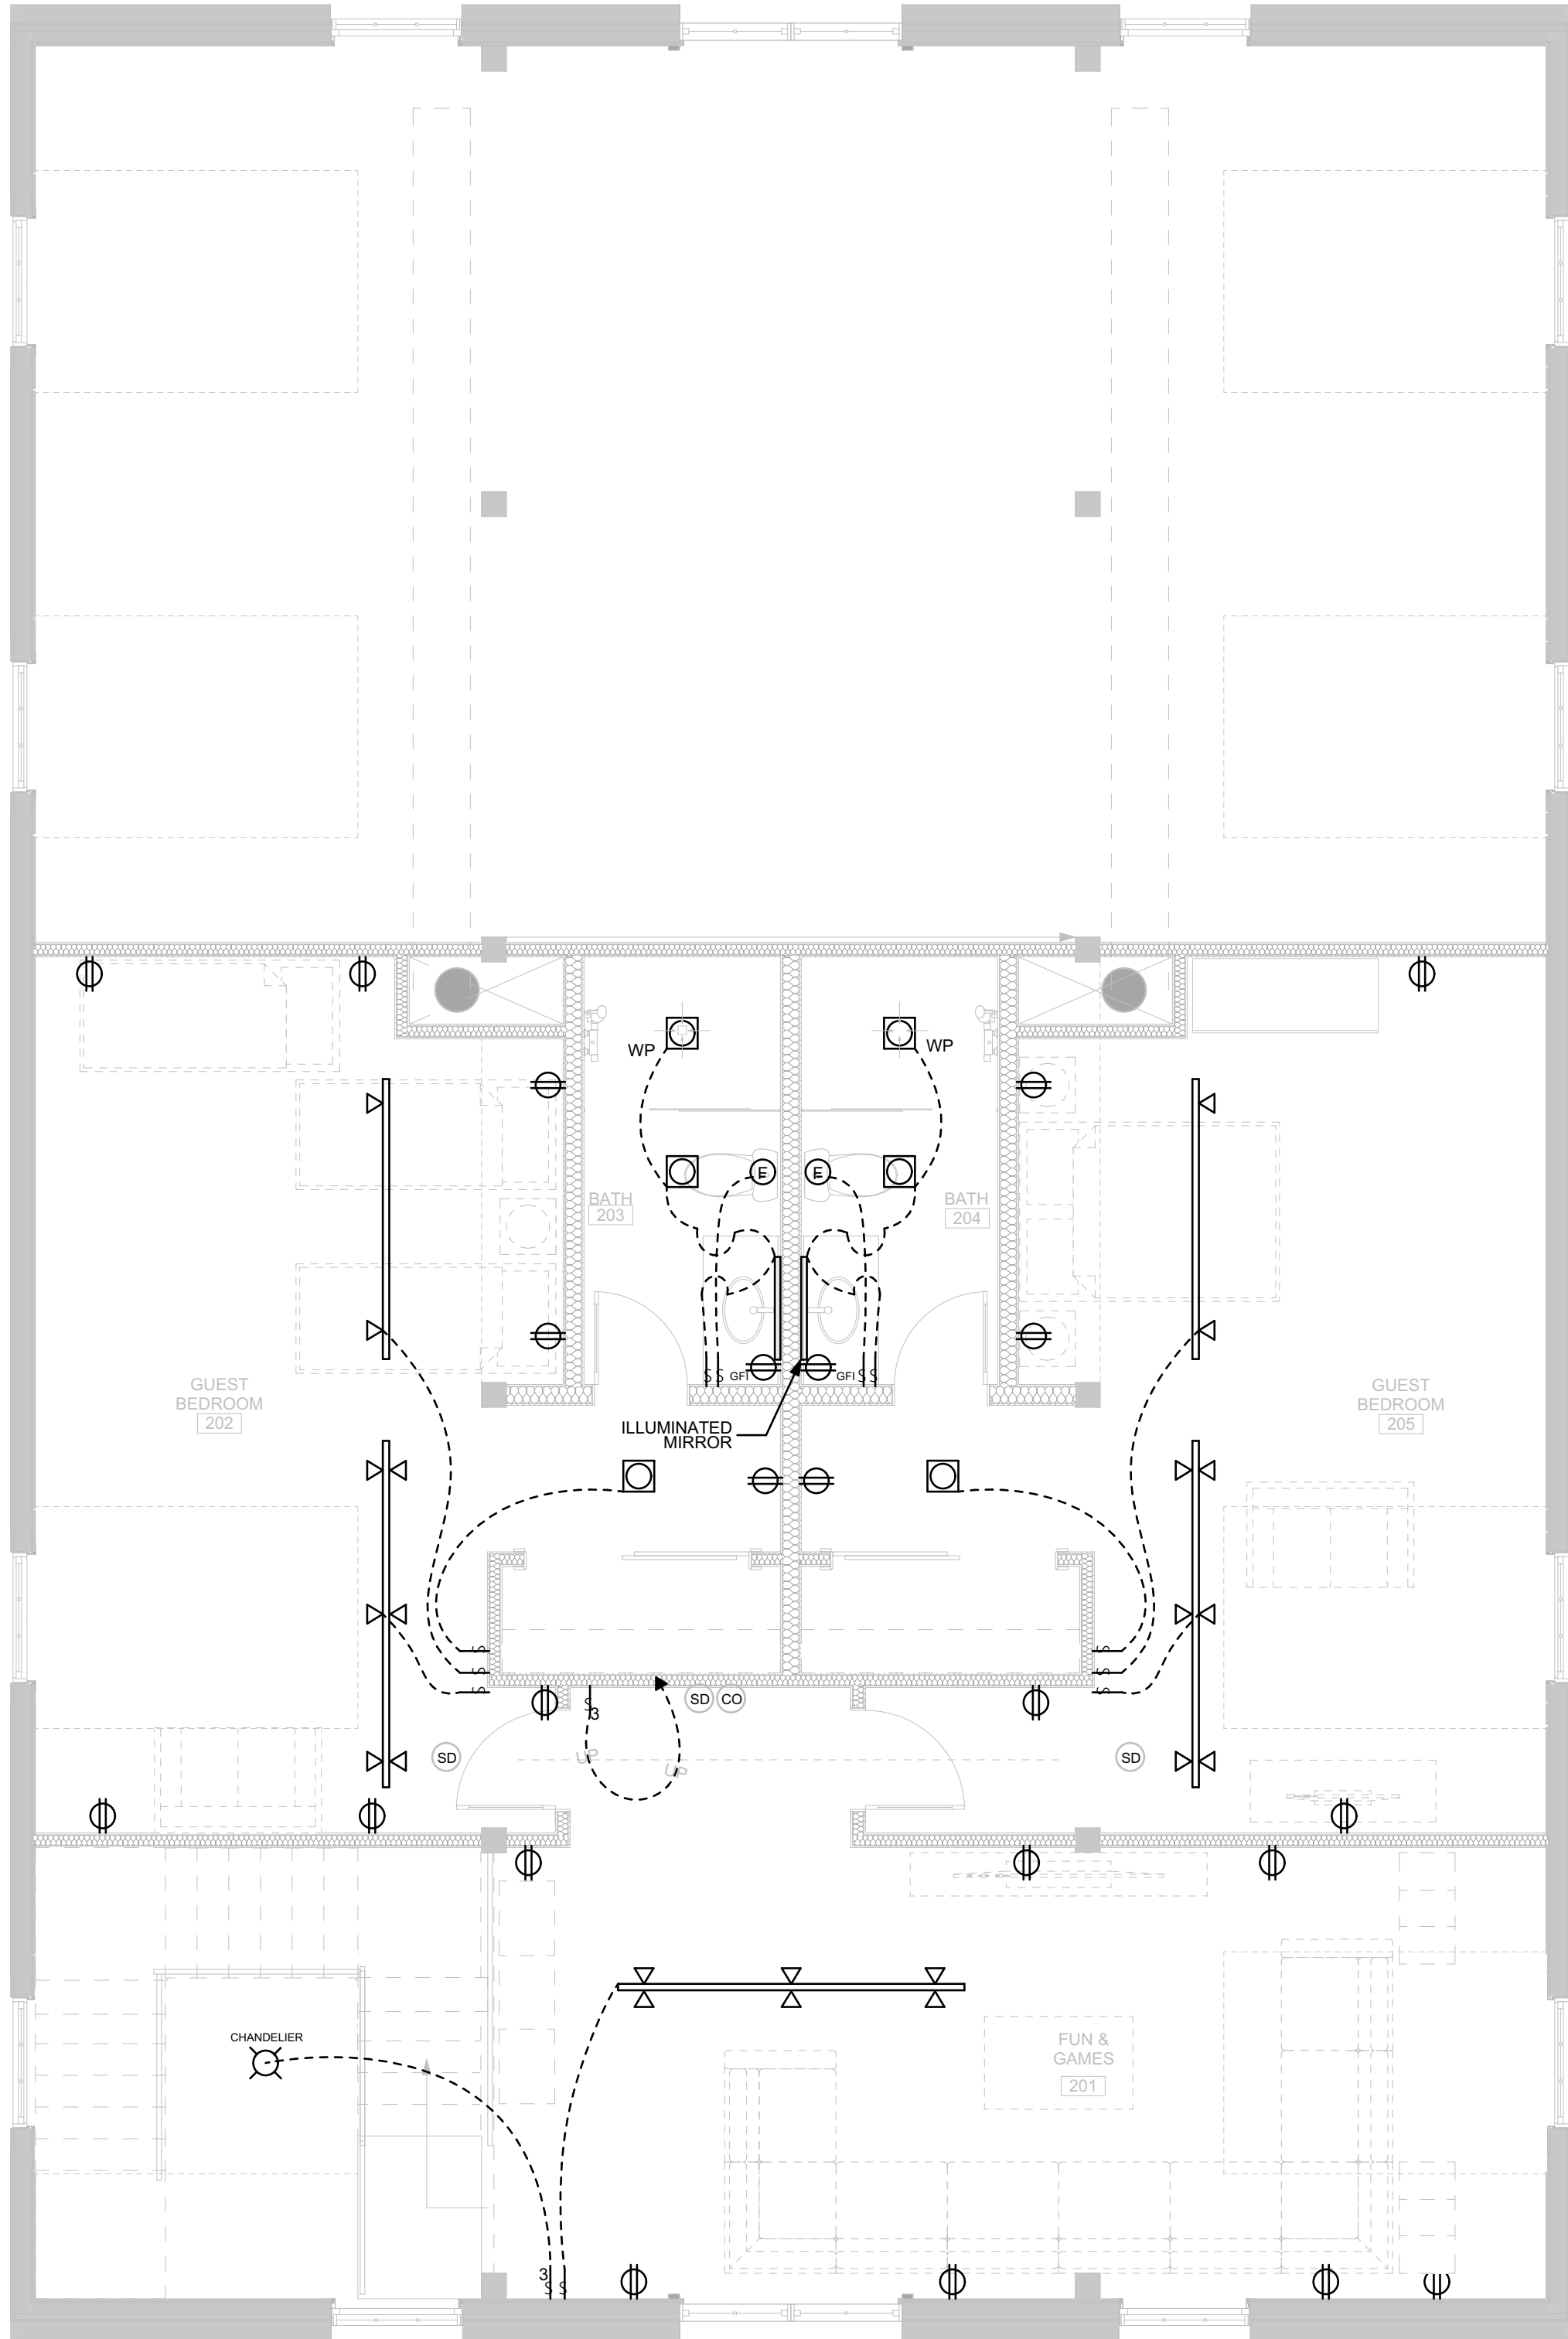


1 UPPER LEVEL ELECTRICAL PLAN
SCALE: 1/4" = 1'-0"

- ELECTRICAL SYMBOLS KEY**
- SURFACE MOUNTED MONOPOINT
 - SURFACE MOUNTED OR HANGING FIXTURE
 - RECESSED CAN FIXTURE
 - RECESSED CAN FIXTURE (WALL WASH)
 - WALL MOUNTED FIXTURE
 - SPOT FIXTURE
 - FLUORESCENT SURFACE MOUNTED FIXTURE
 - UNDER CAB LED FIXTURE
 - TOE KICK LED FIXTURE
 - TRACK LIGHT
 - LANDSCAPE LIGHT
 - DOUBLE FLOOD LIGHT
 - DUPLEX RECEPTACLE OUTLET
 - WATERPROOF DUPLEX RECEPTACLE OUTLET
 - DUPLEX RECEPTACLE OUTLET SPLIT WIRED
 - QUADRUPLUX RECEPTACLE OUTLET
 - DUPLEX RECEPTACLE OUTLET FLOOR MOUNTED
 - 220 VOLT OUTLET
 - TELEPHONE OUTLET
 - CABLE TELEVISION OUTLET
 - CEILING EXHAUST FAN
 - GARAGE DOOR OPENER
 - SINGLE SWITCH
 - THREE-WAY SWITCH
 - FOUR-WAY SWITCH
 - DIMMER SWITCH
 - JUNCTION BOX
 - SMOKE & CARBON MONOXIDE DETECTOR
 - CEILING FAN
 - EXTERIOR SPACE HEATER
 - EXT. STAIR LIGHT
 - ALL FIXTURE AND OUTLET LOCATIONS SUBJECT TO CODE

KELLY & STONE
ARCHITECTS
ARCHITECTURE PLANNING INTERIORS

STEAMBOAT SPRINGS, CO
LAKE TAHOE, CA

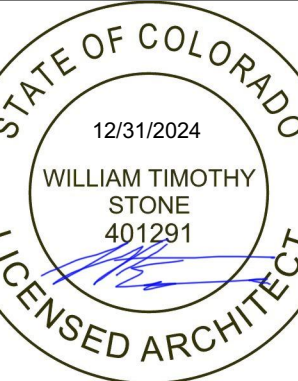

REVIEWED
FOR CODE
COMPLIANCE

10/14/2024

LARSON BARN REMODEL
32130 WILD GOOSE LANE
STEAMBOAT SPRINGS, CO

CD ISSUE SET

ISSUE HISTORY		
ID	NAME	DATE
01	PERMIT SET	07/25/2024
02	PRICING SET	07/29/2024
03	CD SET	09/27/2024
04	DELTA 01	10/07/2024

PROJECT NUMBER: S_2401

SHEET TITLE:
UPPER LEVEL ELECTRICAL
PLAN

SHEET NUMBER:

E.2

© COPYRIGHT KS|a INC.

PLEASE RECYCLE