



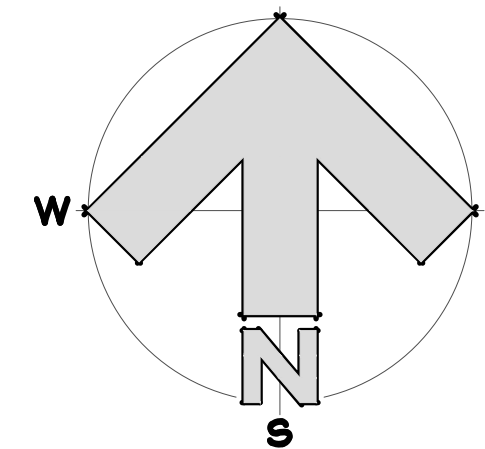


FINISH SCHEDULE

No.	ROOM	FLOORS	BASE	WALLS / CEILINGS	TEXTURE	REMARKS
101	ENTRY	CONCRETE	CARPET	1/2" GYPSUM BOARD	LIGHT ORANGE PEEL	
102	STAIRWAY	HARDWOOD	VINYL SHEET	5/8" TYPE IX"	MEDIUM ORANGE PEEL	
103	BATH	TILE	OTHER	TILE BACKER	HEAVY ORANGE PEEL	
104	KITCHEN	TILE	OAK	CERAMIC TILE	ACOUSTIC	
105	DINING	TILE	VINYL	PANELING	SCRATCH COAT	
106	3-SEASON LIVING	TILE	OTHER	WAINSCOT 36"	KNOCKDOWN	W/ PAVERS
201	LOFT					
202	CLOSET					
203	MASTER BEDROOM					

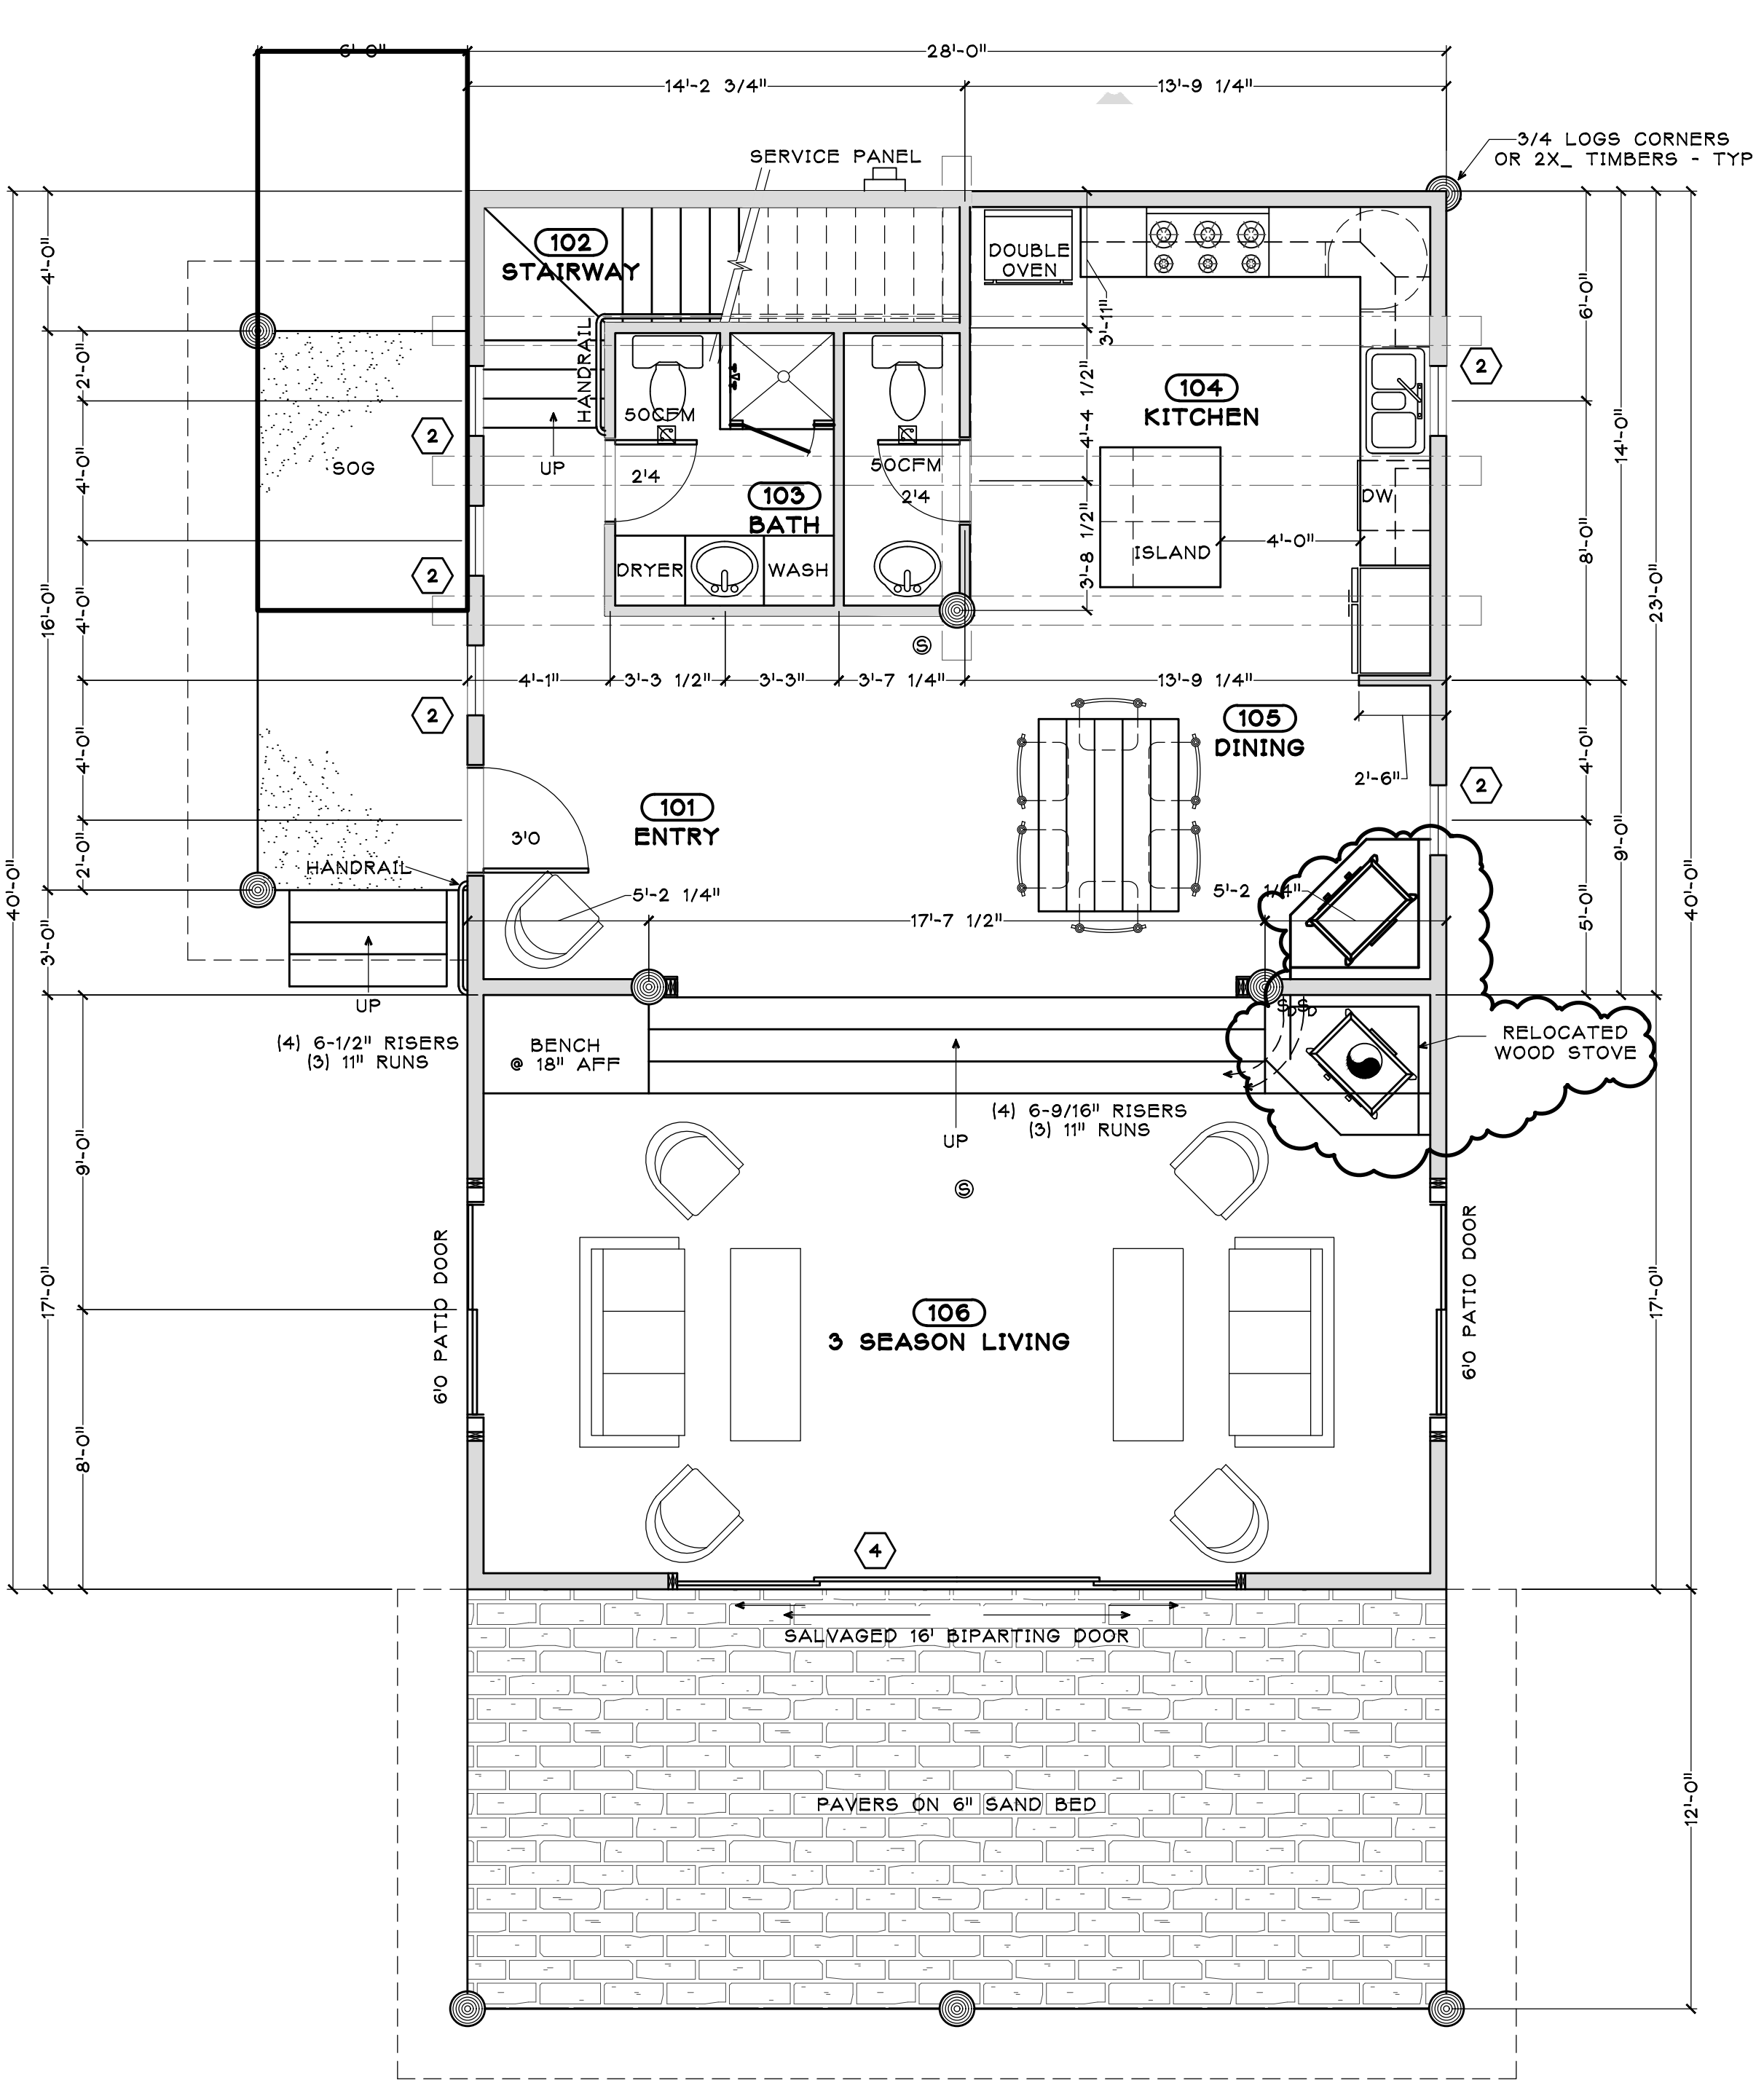

PAVILION FLOOR PLAN

3/16" = 1'-0"

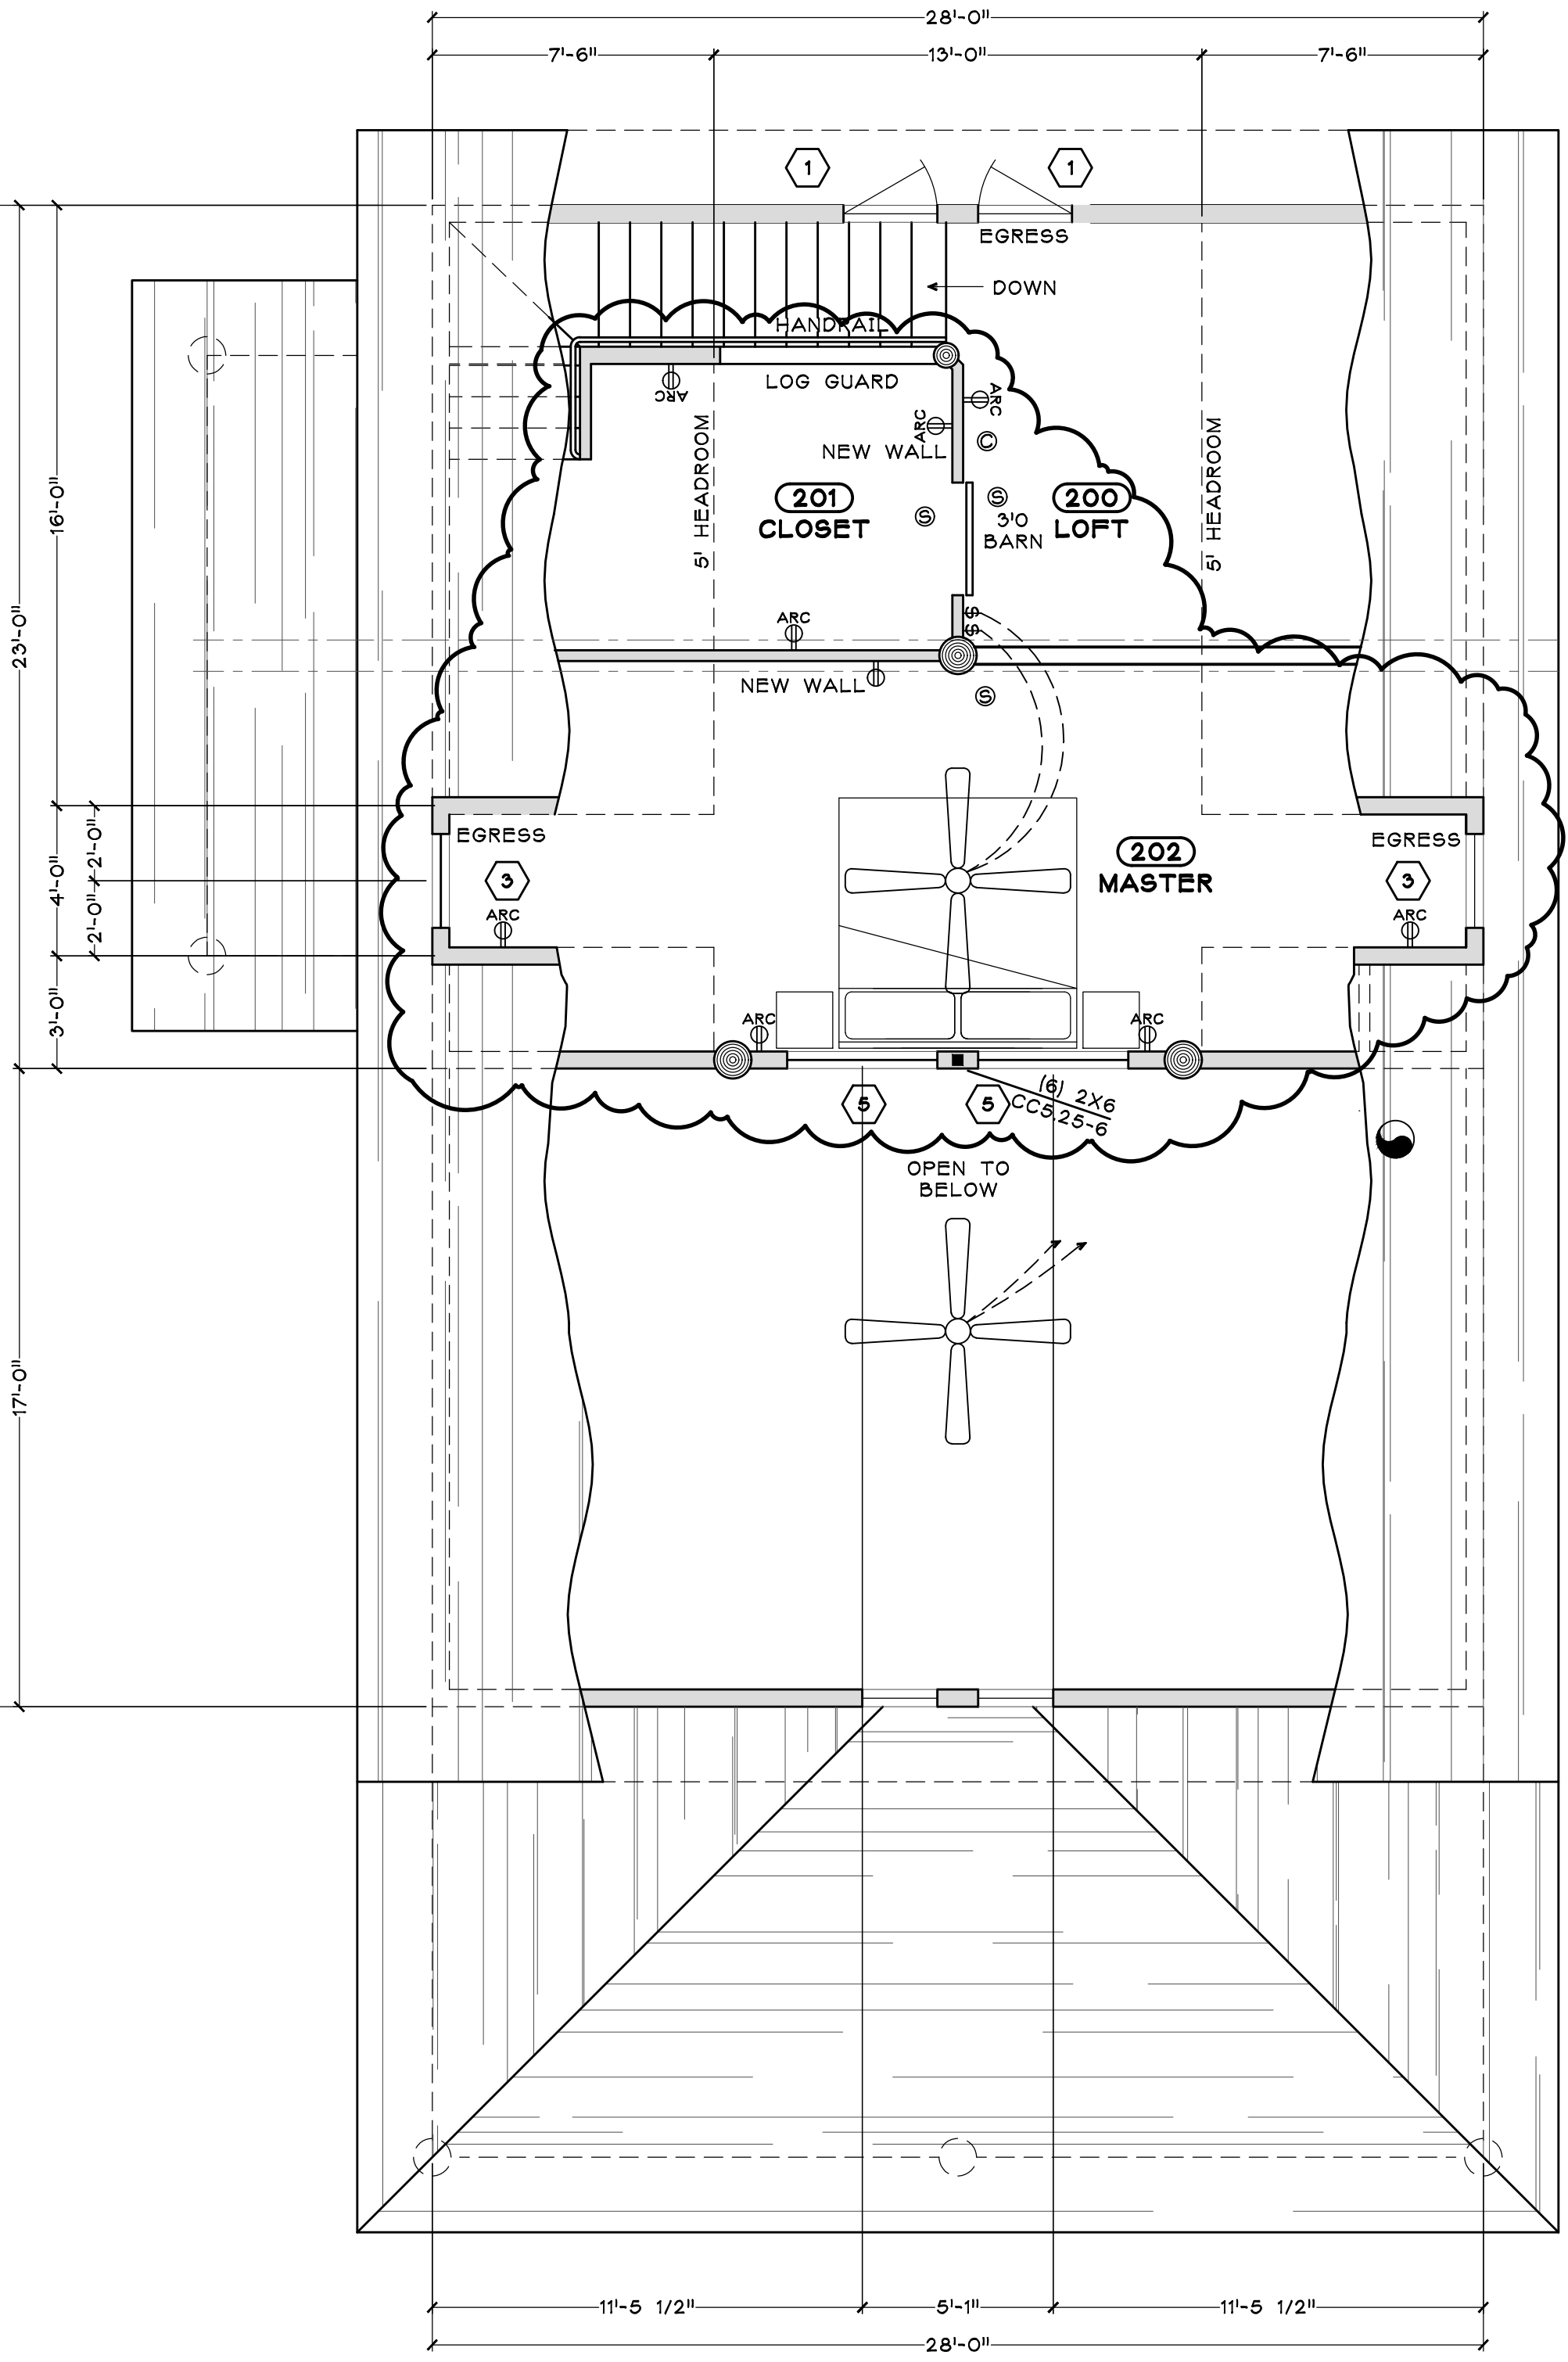

LOFT FLOOR PLAN

3/16" = 1'-0"

ELECTRICAL LEGEND

- ARC 110 VAC DUPLEX RECEPTACLE, ARC-FAULT PROTECTED
- \$ SWITCH
- \$ 3 WAY SWITCH
- \$ DIMMER SWITCH
- SMOKE DETECTOR
- CARBON MONOXIDE DETECTOR

WINDOW SCHEDULE

ITEM	MODEL No.	QTY	ROUGH OPENINGS	HEADER	EGRESS	TEMP'D
1	CC 2848	2	2' 4-3/4" W X 4' 0-1/2" H	VERIFY	X	X
2	DCS 2020	5	2'-1 7/8" W X 4' 1-3/4" H	6'-10"		
3	CC 2848	2	2' 4-3/4" W X 4' 0-1/2" H	6'-10"	X	
4	CC 2848	1	15' 8-1/2" W X 6'-1" H	6'-1"	X	X
5	AC 4824-1	2	4'-0-1/2" X 2'-0-1/2"	VERIFY		

EXISTING ITEM 3 TO BE REMOVED AND REPLACED AS NOTED FOR EGRESS

NOTE:
ALL WINDOWS ARE SEMCO INSULATED LOW E GLAZING, U-VALUE 0.32 MAX
CLAD COLOR DARK GREEN
ALL OPERABLE UNITS TO BE PROVIDED W/ SCREENS

CONSTRUCTION TYPE : VB
OCCUPANCY : R3
BUILDING AREAS :

MAIN LEVEL FINISHED :
UPPER LEVEL FINISHED : 185 SF (NEW)
3 SEASON LIVING
PORCH :
PORCH :
TOTAL : 185 SF (NEW)

NOTE: THESE PLANS WERE PREPARED FOR HAROLD GARDNER & MARILYN FISKE UNDER PERMIT B-07-274. THESE PLANS WILL MODIFY THE ORIGINAL HOUSE. MODIFICATIONS ARE SHOWN CLOUDED TO DISTINGUISH NEW WORK TO BE PERMITTED AND EXISTING CONDITIONS. WORK PERMITTED UNDER B-20-151 IS SHOWN AS EXISTING CONDITIONS.

DRAFTING SERVICE, INC.
P.O. BOX 174121
426 OAK STREET
STEAMBOAT SPRINGS, COLORADO 80486
970.874.7929
FAX 970.874.8709
JAKES@SPRINGSIPS.COM

Jake's



FLOOR PLANS, SCHEDULES & LEGENDS FOR

the CASEY BOURQUE RESIDENCE

30385 BLACKTAIL LANE
ROUTT COUNTY, COLORADO
OWNER/CONTRACTOR, 303.514.5418

Job # 20005A10
File 20005A10
Date 17MAR20
Drawn JMH
Checked JMH
Revised JMH

Sheet Number

A

SHEET 3 OF 6