


LEGEND

- 6' CHAIN LINK FENCE WITH BARBED WIRE
- LEASE LINE
- HIDDEN LINE
- CONCRETE
- RF NOTICE SIGN
- RF CAUTION SIGN
- COMPANY IDENTIFIER
- PROPANE LABEL
- NO SMOKING SIGN
- NEW/CHANGED EQUIPMENT
- RETIRE EQUIPMENT
- COLOCATION EQUIPMENT

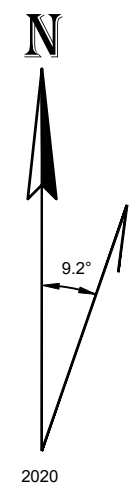

REVIEWED
FOR
CODE
COMPLIANCE
11/16/2021

Union
WIRELESS

850 N. HIGHWAY 414
PO BOX 160
MOUNTAIN VIEW, WY 82939

THE INFORMATION CONTAINED IN THIS DOCUMENT IS PROPRIETARY. ANY USE OR DISCLOSURE OTHER THAN THOSE AUTHORIZED BY UNION TELEPHONE COMPANY IS STRICTLY PROHIBITED.

CURRENT REV	DATE
G	10/25/2021
DESIGNER:	GREG WILLIAMS
REVIEWER:	MATT FISHER



APPROVED
FOR
CONSTRUCTION
25 OCTOBER 2021

PROJECT NAME:

HAYDEN

PROJECT ADDRESS:


6985 HOMESTEADER LANE 2
HAYDEN, ROUTT COUNTY, COLORADO

SHEET TITLE:

PLAN VIEW

SHEET NUMBER:

C1

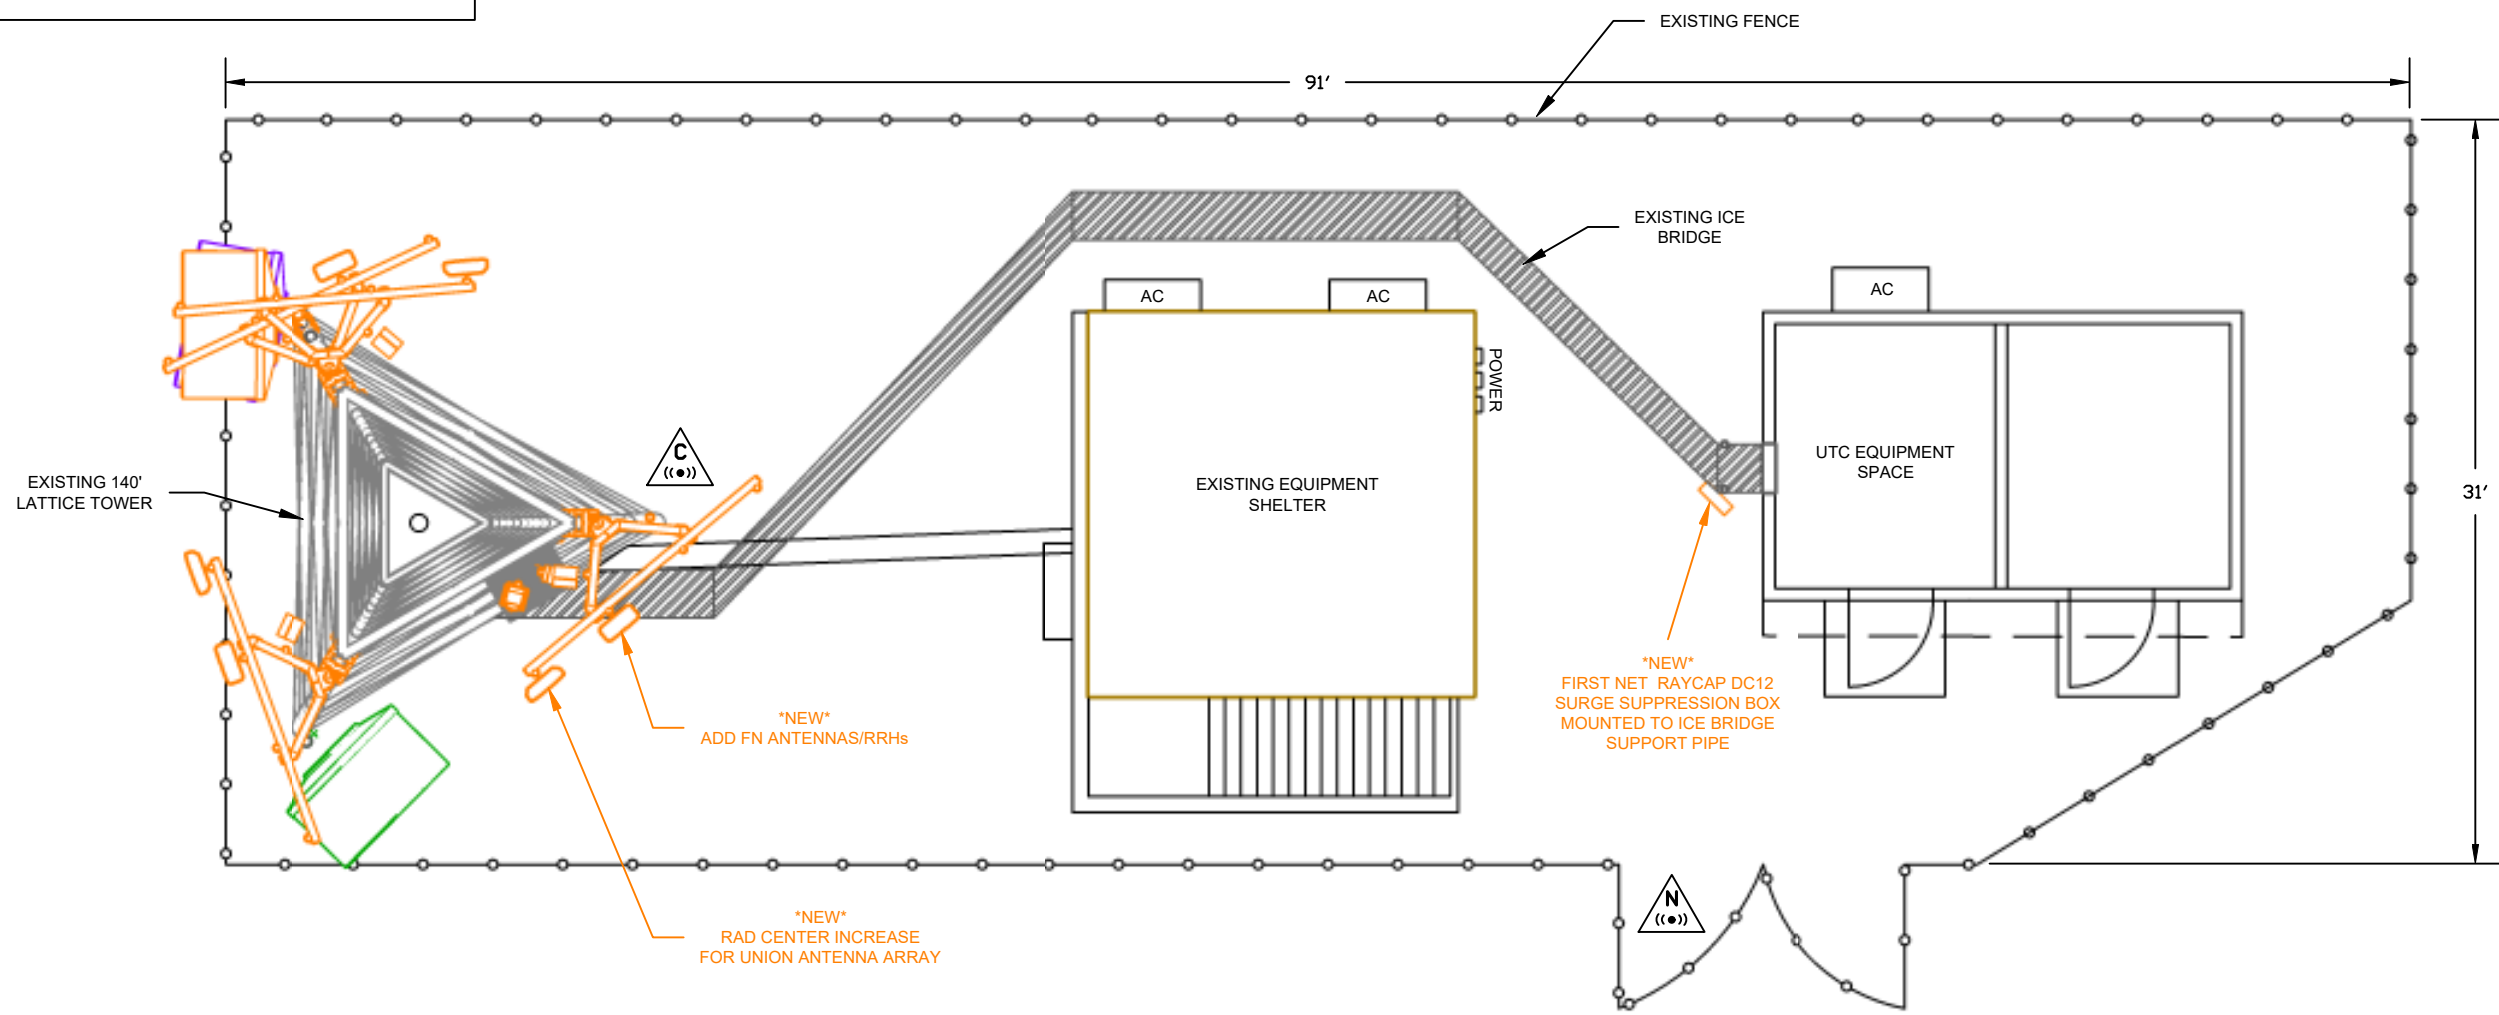


1
C2 FIRST NETSITE PLAN
SCALE: 1/8"=1'

LEGEND


NEW EQUIPMENT

RETIRE EQUIPMENT

NOTE:
STRUCTURAL AND MOUNT
ANALYSIS BY OTHERS.

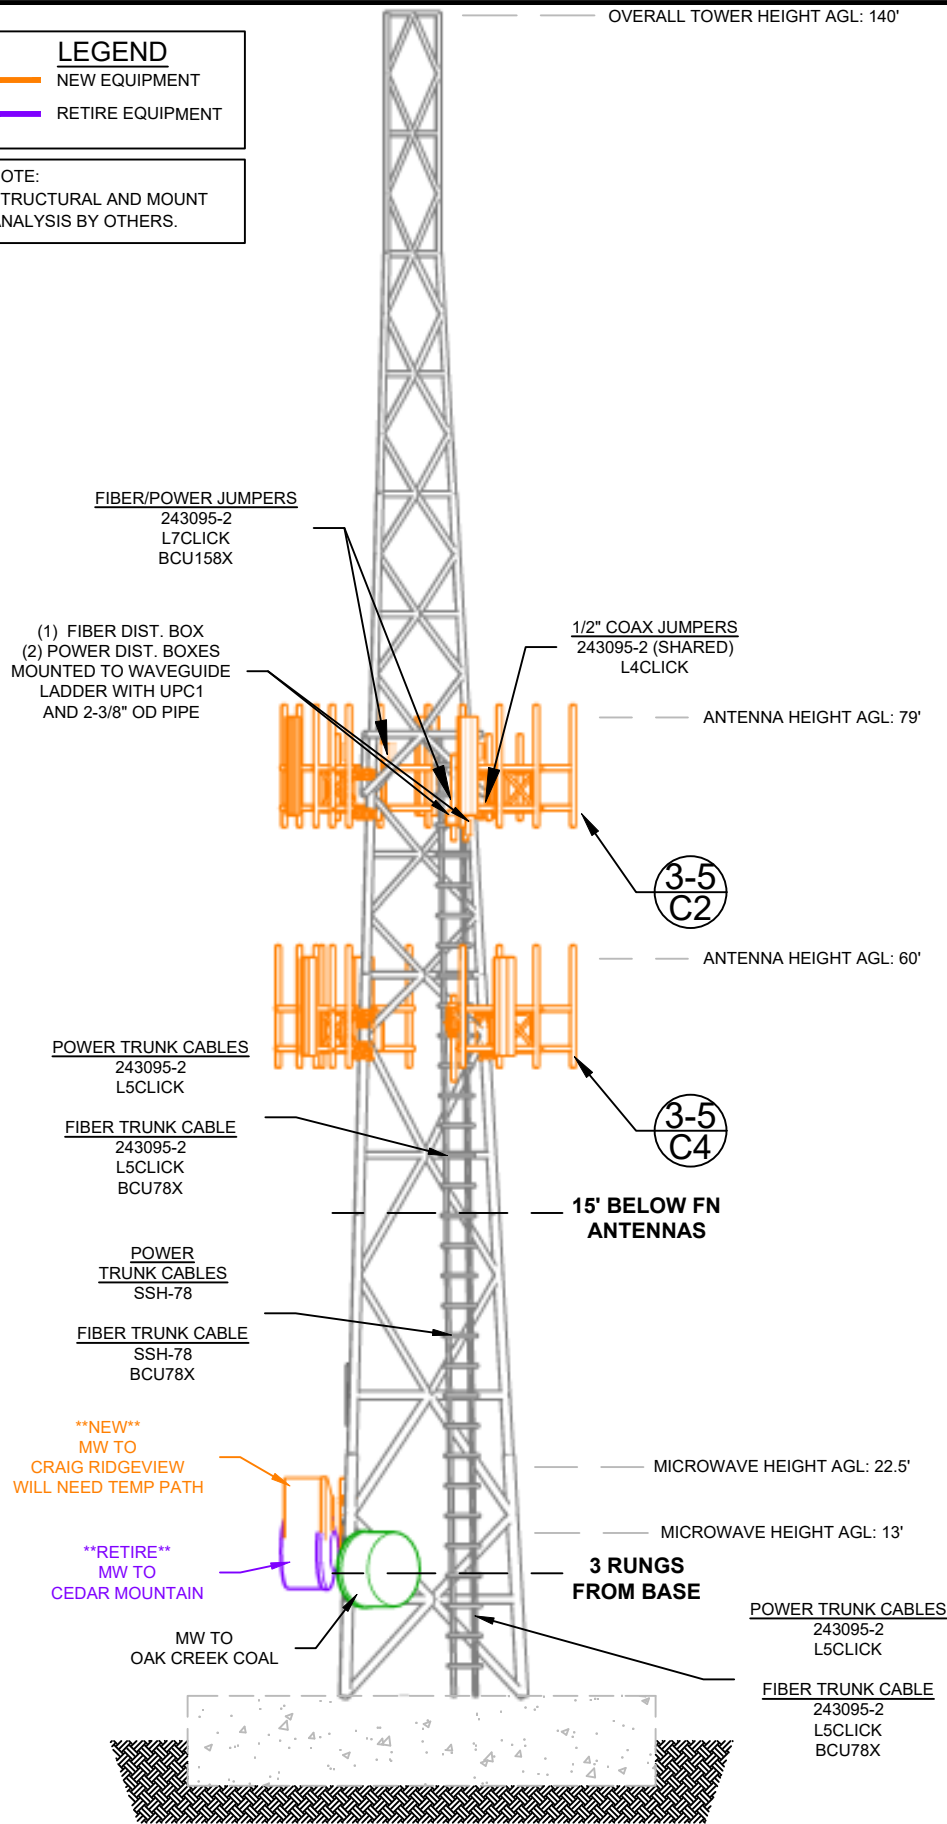


1 SOUTH FACE ELEVATION
SCALE: 1/16"=1'

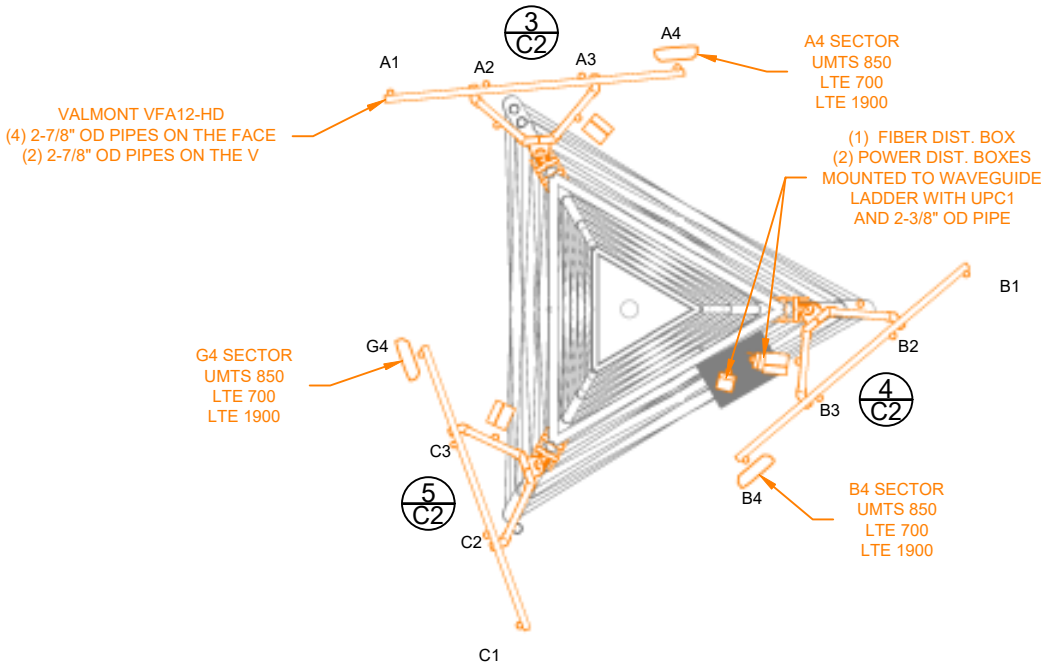

2 ANTENNA DETAILS
SCALE: 1/8"=1'

3 ANTENNA DETAILS	
A4 SECTOR	ANTENNA MANUFACTURER & MODEL: 1x KMW EPBQ-654L8H8-L2-EPI
	AZIMUTH: 346° MAG (355° TRUE)
	TIP HEIGHT ABOVE GROUND LEVEL: 79'
	TECHNOLOGY 698-894 MHz PORTS: UMTS 850 F1/F2, LTE 700 2x2
	DOWNTILT 698-894 MHz PORTS: 0° MECH, RET (SEE BUILDSHEET)
	COAX 698-894 MHz PORTS: 4x 1/2" COAX JUMPER
	TECHNOLOGY 1710-2170 MHz PORTS: LTE 1900 2x4
	DOWNTILT 1710-2170 MHz PORTS: 0° MECH, RET (SEE BUILDSHEET)
B4 SECTOR	COAX SPECS 1710-2170 MHz PORTS: 4x 1/2" COAX JUMPER, 4x PORTS CAPPED
	ANTENNA MANUFACTURER & MODEL: 1x KMW EPBQ-654L8H8-L2-EPI
	AZIMUTH: 131° MAG (140° TRUE)
	TIP HEIGHT ABOVE GROUND LEVEL: 79'
	TECHNOLOGY 698-894 MHz PORTS: UMTS 850 F1/F2, LTE 700 2x2
	DOWNTILT 698-894 MHz PORTS: 0° MECH, RET (SEE BUILDSHEET)
	COAX 698-894 MHz PORTS: 4x 1/2" COAX JUMPER
	TECHNOLOGY 1710-2170 MHz PORTS: LTE 1900 2x4
G4 SECTOR	DOWNTILT 1710-2170 MHz PORTS: 0° MECH, RET (SEE BUILDSHEET)
	COAX SPECS 1710-2170 MHz PORTS: 4x 1/2" COAX JUMPER, 4x PORTS CAPPED
	ANTENNA MANUFACTURER & MODEL: 1x KMW EPBQ-654L8H8-L2-EPI
	AZIMUTH: 241° MAG (250° TRUE)
	TIP HEIGHT ABOVE GROUND LEVEL: 79'
	TECHNOLOGY 698-894 MHz PORTS: UMTS 850 F1/F2, LTE 2x2
	DOWNTILT 698-894 MHz PORTS: 0° MECH, RET (SEE BUILDSHEET)
	COAX 698-894 MHz PORTS: 4x 1/2" COAX JUMPER
B4 SECTOR	TECHNOLOGY 1710-2170 MHz PORTS: LTE 1900 2x4
	DOWNTILT 1710-2170 MHz PORTS: 0° MECH, RET (SEE BUILDSHEET)
	COAX SPECS 1710-2170 MHz PORTS: 4x 1/2" COAX JUMPER, 4x PORTS CAPPED
	ANTENNA MANUFACTURER & MODEL: 1x KMW EPBQ-654L8H8-L2-EPI
	AZIMUTH: 241° MAG (250° TRUE)
	TIP HEIGHT ABOVE GROUND LEVEL: 79'
	TECHNOLOGY 698-894 MHz PORTS: UMTS 850 F1/F2, LTE 2x2
	DOWNTILT 698-894 MHz PORTS: 0° MECH, RET (SEE BUILDSHEET)
G4 SECTOR	COAX 698-894 MHz PORTS: 4x 1/2" COAX JUMPER
	TECHNOLOGY 1710-2170 MHz PORTS: LTE 1900 2x4
	DOWNTILT 1710-2170 MHz PORTS: 0° MECH, RET (SEE BUILDSHEET)
	COAX SPECS 1710-2170 MHz PORTS: 4x 1/2" COAX JUMPER, 4x PORTS CAPPED
	ANTENNA MANUFACTURER & MODEL: 1x KMW EPBQ-654L8H8-L2-EPI
	AZIMUTH: 241° MAG (250° TRUE)
	TIP HEIGHT ABOVE GROUND LEVEL: 79'
	TECHNOLOGY 698-894 MHz PORTS: UMTS 850 F1/F2, LTE 2x2
B4 SECTOR	DOWNTILT 698-894 MHz PORTS: 0° MECH, RET (SEE BUILDSHEET)
	COAX 698-894 MHz PORTS: 4x 1/2" COAX JUMPER
	TECHNOLOGY 1710-2170 MHz PORTS: LTE 1900 2x4
	DOWNTILT 1710-2170 MHz PORTS: 0° MECH, RET (SEE BUILDSHEET)
	COAX SPECS 1710-2170 MHz PORTS: 4x 1/2" COAX JUMPER, 4x PORTS CAPPED
	ANTENNA MANUFACTURER & MODEL: 1x KMW EPBQ-654L8H8-L2-EPI
	AZIMUTH: 241° MAG (250° TRUE)
	TIP HEIGHT ABOVE GROUND LEVEL: 79'
G4 SECTOR	TECHNOLOGY 698-894 MHz PORTS: UMTS 850 F1/F2, LTE 2x2
	DOWNTILT 698-894 MHz PORTS: 0° MECH, RET (SEE BUILDSHEET)
	COAX 698-894 MHz PORTS: 4x 1/2" COAX JUMPER
	TECHNOLOGY 1710-2170 MHz PORTS: LTE 1900 2x4
	DOWNTILT 1710-2170 MHz PORTS: 0° MECH, RET (SEE BUILDSHEET)
	COAX SPECS 1710-2170 MHz PORTS: 4x 1/2" COAX JUMPER, 4x PORTS CAPPED
	ANTENNA MANUFACTURER & MODEL: 1x KMW EPBQ-654L8H8-L2-EPI
	AZIMUTH: 241° MAG (250° TRUE)
B4 SECTOR	TIP HEIGHT ABOVE GROUND LEVEL: 79'
	TECHNOLOGY 698-894 MHz PORTS: UMTS 850 F1/F2, LTE 2x2
	DOWNTILT 698-894 MHz PORTS: 0° MECH, RET (SEE BUILDSHEET)
	COAX 698-894 MHz PORTS: 4x 1/2" COAX JUMPER
	TECHNOLOGY 1710-2170 MHz PORTS: LTE 1900 2x4
	DOWNTILT 1710-2170 MHz PORTS: 0° MECH, RET (SEE BUILDSHEET)
	COAX SPECS 1710-2170 MHz PORTS: 4x 1/2" COAX JUMPER, 4x PORTS CAPPED
	ANTENNA MANUFACTURER & MODEL: 1x KMW EPBQ-654L8H8-L2-EPI
G4 SECTOR	AZIMUTH: 241° MAG (250° TRUE)
	TIP HEIGHT ABOVE GROUND LEVEL: 79'
	TECHNOLOGY 698-894 MHz PORTS: UMTS 850 F1/F2, LTE 2x2
	DOWNTILT 698-894 MHz PORTS: 0° MECH, RET (SEE BUILDSHEET)
	COAX 698-894 MHz PORTS: 4x 1/2" COAX JUMPER
	TECHNOLOGY 1710-2170 MHz PORTS: LTE 1900 2x4
	DOWNTILT 1710-2170 MHz PORTS: 0° MECH, RET (SEE BUILDSHEET)
	COAX SPECS 1710-2170 MHz PORTS: 4x 1/2" COAX JUMPER, 4x PORTS CAPPED

 REVIEWED
FOR
CODE
COMPLIANCE
11/16/2021



850 N. HIGHWAY 414
PO BOX 160
MOUNTAIN VIEW, WY 82939

THE INFORMATION CONTAINED IN THIS
DOCUMENT IS PROPRIETARY. ANY USE OR
DISCLOSURE OTHER THAN THOSE AUTHORIZED
BY UNION TELEPHONE COMPANY IS STRICTLY
PROHIBITED.

CURRENT REV	DATE
G	10/25/2021

DESIGNER:
GREG WILLIAMS

REVIEWER:
MATT FISHER



APPROVED
FOR
CONSTRUCTION
25 OCTOBER 2021

PROJECT NAME:

HAYDEN

PROJECT ADDRESS:

6985 HOMESTEADER LANE 2
HAYDEN, ROUTT COUNTY, COLORADO

SHEET TITLE:

ANTENNA DETAILS

SHEET NUMBER:


C2

LEGEND


NEW EQUIPMENT

RETIRE EQUIPMENT

NOTE:
STRUCTURAL AND MOUNT
ANALYSIS BY OTHERS.

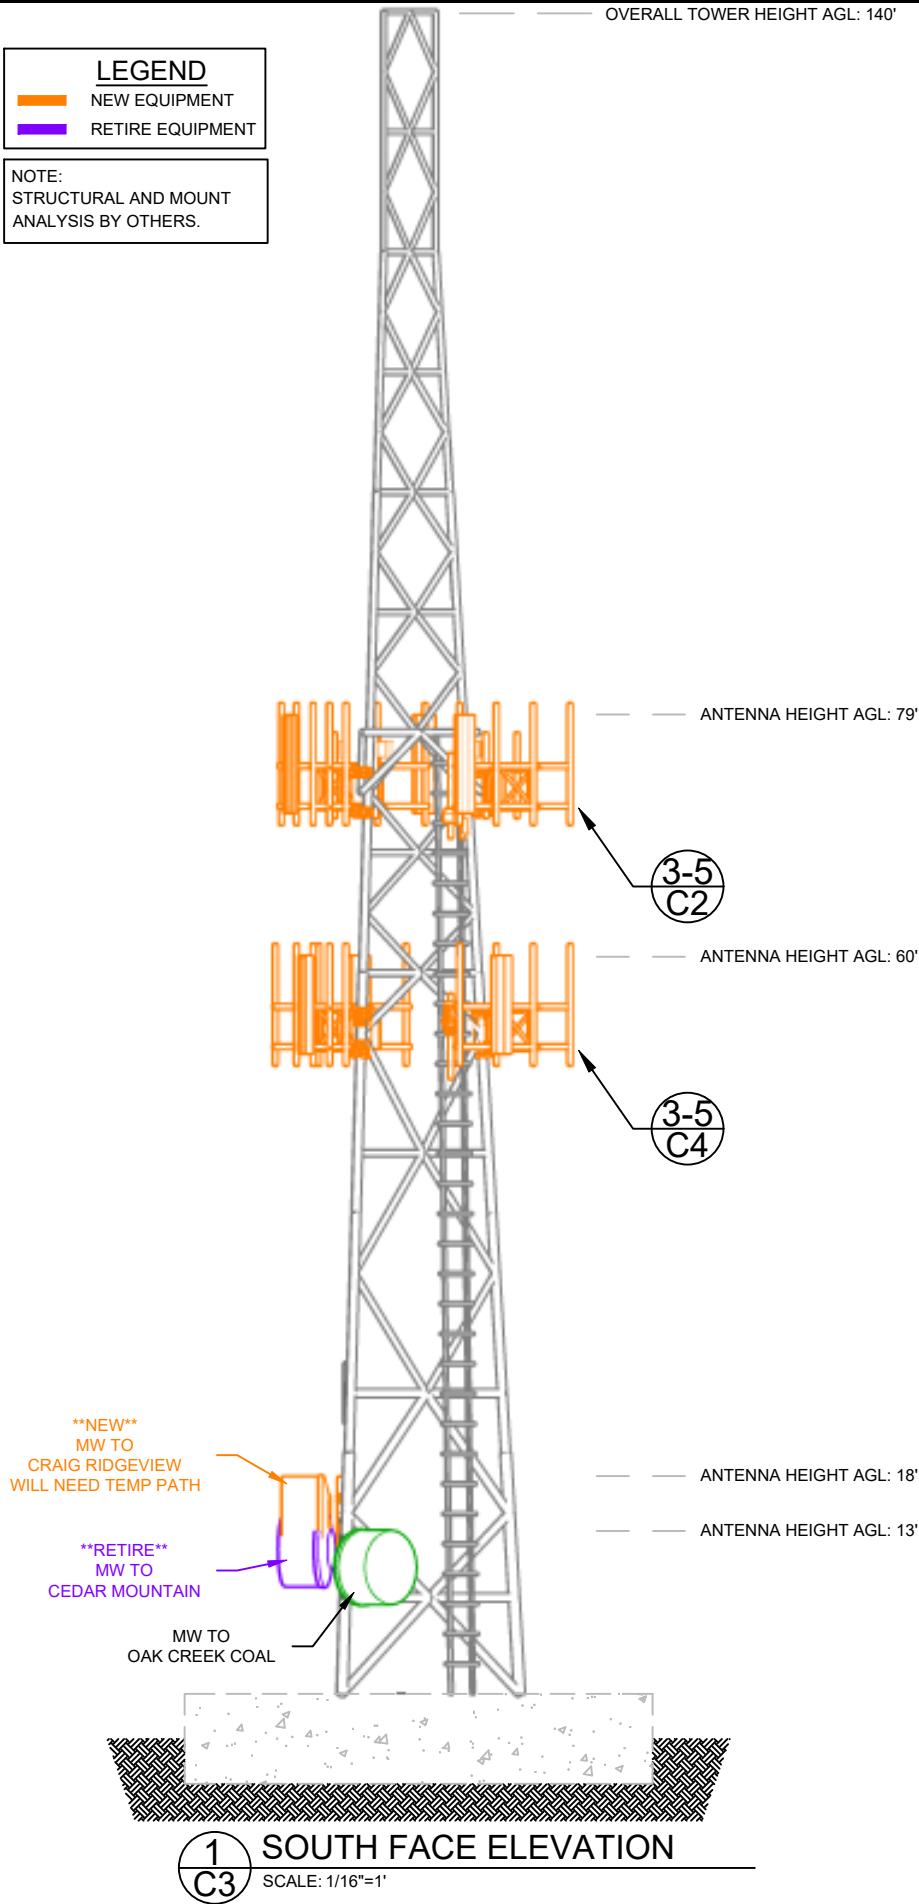

PLEASE NOTE: ONLY UNION EQUIPMENT
SHOWN FOR CLARITY.

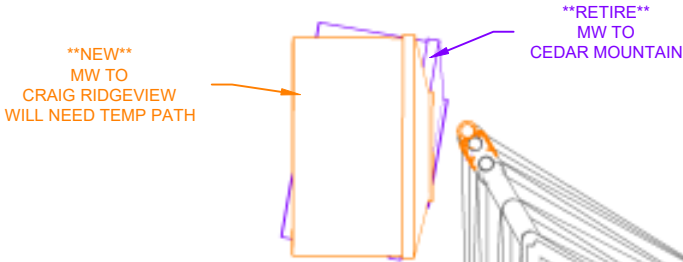

2 ANTENNA DETAILS
3 C3 SCALE: 3/16"=1'

3 MW DETAILS
C3

MW TO CEDAR MTN				MW TO OAK CREEK COAL			
MW TO CEDAR MTN	ANTENNA MANUFACTURER & MODEL:			HP6-107, VERTICAL			HPX8-65-P6A
	AZIMUTH:			271° MAG (280.8° TRUE)			125° MAG (134.6° TRUE)
	HEIGHT ABOVE CONCRETE LEVEL:			15'			12'
	POLARIZATION:			Tx:V, Rx:V			Tx:V&H, Rx:V&H
	TECHNOLOGY/FREQUENCY/SHARED:			LICENSED 11 GHz			LICENSED 6 GHz
	WAVEGUIDE SPECIFICATIONS:			(1x) EW90 FEED			(2x) EW63 FEEDLINES
MW TO CRAIG RIDGEVIEW	MICROWAVE PATH TO:			CRAIG RIDGEVIEW			
	ANTENNA MANUFACTURER & MODEL:			ANDREW (1X) USX6-6W			
	AZIMUTH:			261° MAG (270.2° TRUE)			
	HEIGHT ABOVE CONCRETE LEVEL:			15'			
	POLARIZATION:			TX: V&H RX: V&H			
	ODU PLACEMENT HORIZONTAL POLARIZATION:			RFU-HP - POLE MOUNT			
MW TO OAK CREEK COAL	ODU PLACEMENT VERTICAL POLARIZATION:			RFU-HP - POLE MOUNT			
	TECHNOLOGY/FREQUENCY:			L6GHZ			
	WAVEGUIDE SPECIFICATIONS:			(2) LDF4-50A			

REVIEWED
FOR
CODE
COMPLIANCE
11/16/2021



850 N. HIGHWAY 414
PO BOX 160
MOUNTAIN VIEW, WY 82939

THE INFORMATION CONTAINED IN THIS
DOCUMENT IS PROPRIETARY. ANY USE OR
DISCLOSURE OTHER THAN THOSE AUTHORIZED
BY UNION TELEPHONE COMPANY IS STRICTLY
PROHIBITED.

CURRENT REV	DATE
G	10/25/2021

DESIGNER:
GREG WILLIAMS

REVIEWER:
MATT FISHER



APPROVED
FOR
CONSTRUCTION
25 OCTOBER 2021

PROJECT NAME:

HAYDEN

PROJECT ADDRESS:

6985 HOMESTEADER LANE 2
HAYDEN, ROUTT COUNTY, COLORADO

SHEET TITLE:


MICROWAVE DETAILS

SHEET NUMBER:


C3

SECTOR A4
UMTS 850 F1/F2
LTE 700 2x2
LTE 1900 2x4

KMW
EPBQ-654LH8-L2-EPI

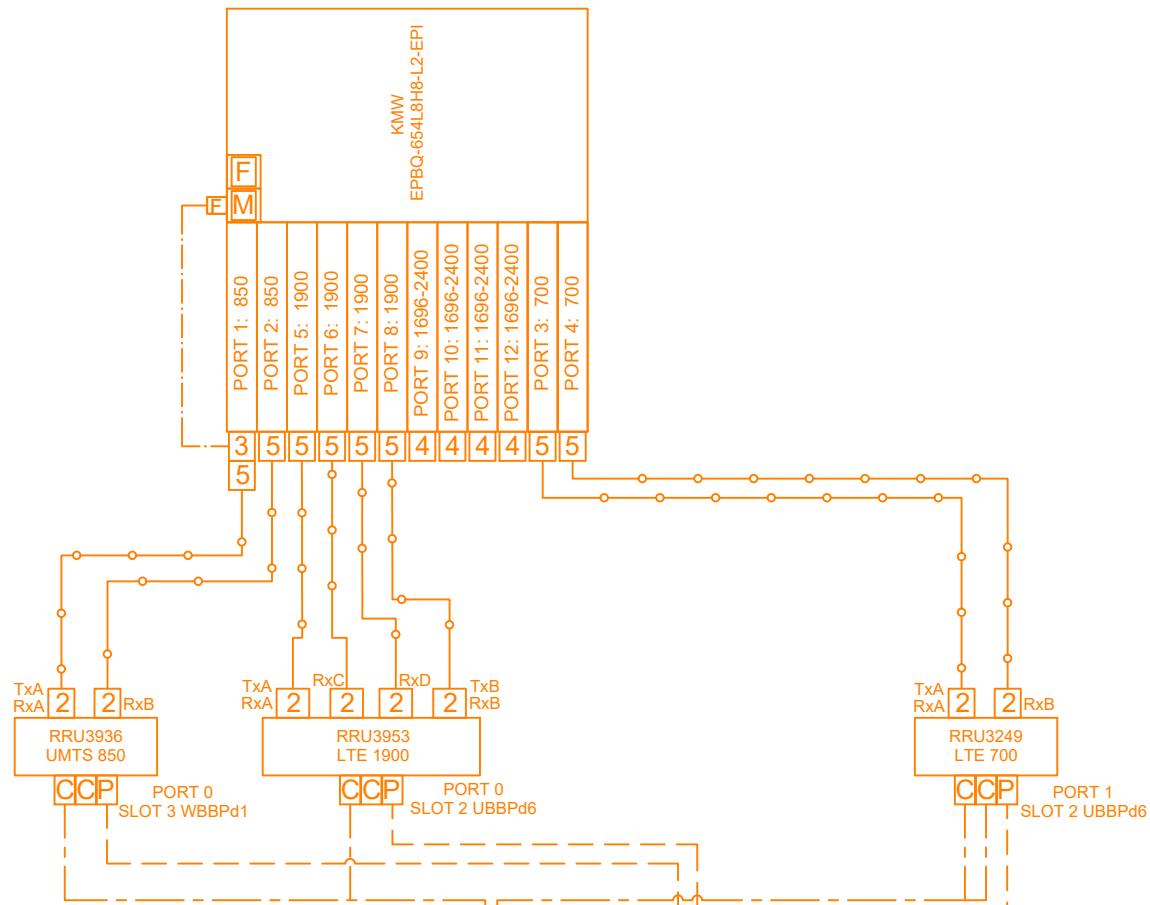

**EQUIPMENT SHARED
FOR ALL SECTORS
BELOW LINE**

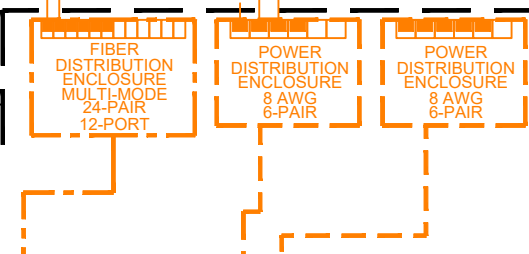



OUTDOOR CONFIGURATION

INSIDE BUILDING

CPRI PANEL

BBU CARD

 CPRI PANEL - SINGLE MODE

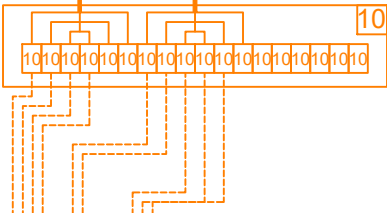

1
R1

RAN CABLING DIAGRAM - ALPHA SECTOR

SCALE: NO SCALE

LEGEND

- 1/2" JUMPER 4.3-10(M)-DIN(M) - 15'
- 1/2" JUMPER 4.3-10(M)-4.3-10(M)
- TRUNK FIBER CABLE - 6 PAIR 3AWG
- ROS FB-L98B-A0303-190FT
- TRUNK POWER CABLE - 3 PAIR 3AWG
- ROS PR-UWPT812-190FT
- TWO PAIR SM FIBER - PLUG N PLAY
- ROS FB-L98B-A0302-7000/10000
- SINGLE PAIR #12 POWER - PLUG N PLAY
- ROS L99-P055-7000/10000
- SINGLE PAIR FIBER CABLE - SM
- SINGLE PAIR POWER CABLE
- (1x) LDF4-50A
- (1x) RET CABLE
- (1x) LMR-400 CABLE
- NEW EQUIPMENT
- GROUND KIT
- 1/2" DIN MALE CONNECTOR
- SBT-8F-64-01
- RL-65Z001-000N CAP
- 1/2" 4.3-10 MINI DIN MALE CONNECTOR
- APG-BNFN-350
- LMR-400 N MALE CONNECTOR
- LMR-400 SMA MALE CONNECTOR
- L4TNM-PSA
- RUWCD-2978-P-48
- BA384 ENTRY BOOT KIT
- BA783 ENTRY BOOT KIT
- BA124 ENTRY BOOT KIT
- FEMALE RET CONNECTOR
- MALE RET CONNECTOR
- RRU CPRI PORT
- RRU POWER PORT

REVIEWED
FOR
CODE
COMPLIANCE
11/16/2021



850 N. HIGHWAY 414
PO BOX 160
MOUNTAIN VIEW, WY 82939

THE INFORMATION CONTAINED IN THIS DOCUMENT IS PROPRIETARY. ANY USE OR DISCLOSURE OTHER THAN THOSE AUTHORIZED BY UNION TELEPHONE COMPANY IS STRICTLY PROHIBITED.

CURRENT REV	DATE
G	10/25/2021

DESIGNER: GREG WILLIAMS

REVIEWER: MATT FISHER



APPROVED
FOR
CONSTRUCTION
25 OCTOBER 2021

PROJECT NAME:

HAYDEN

PROJECT ADDRESS:


6985 HOMESTEADER LANE 2
HAYDEN, ROUTT COUNTY, COLORADO

SHEET TITLE:

RAN DIAGRAM - A SECTOR

SHEET NUMBER:


R1

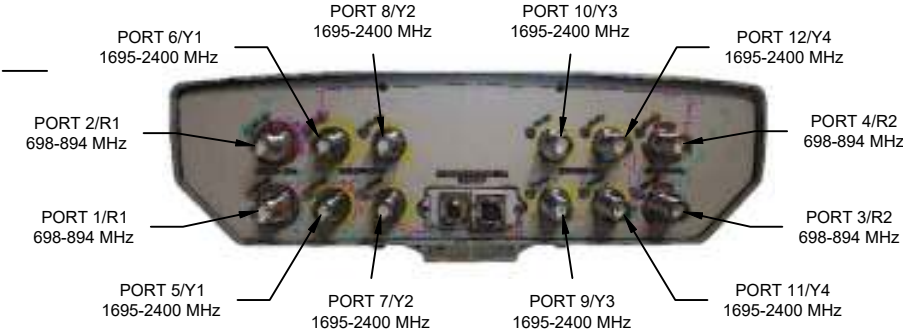


Frequency Range	Array	Connector
880-894MHz	R1	4.3-10 Female
880-894MHz	R2	4.3-10 Female
1695-2400MHz	Y1	4.3-10 Female
1695-2400MHz	Y2	4.3-10 Female
1695-2400MHz	Y3	4.3-10 Female
1695-2400MHz	Y4	4.3-10 Female

SECTOR B4
UMTS 850 F1/F2
LTE 700 2x2
LTE 1900 2x4

KMW
EPBQ-654LH8-L2-EPI



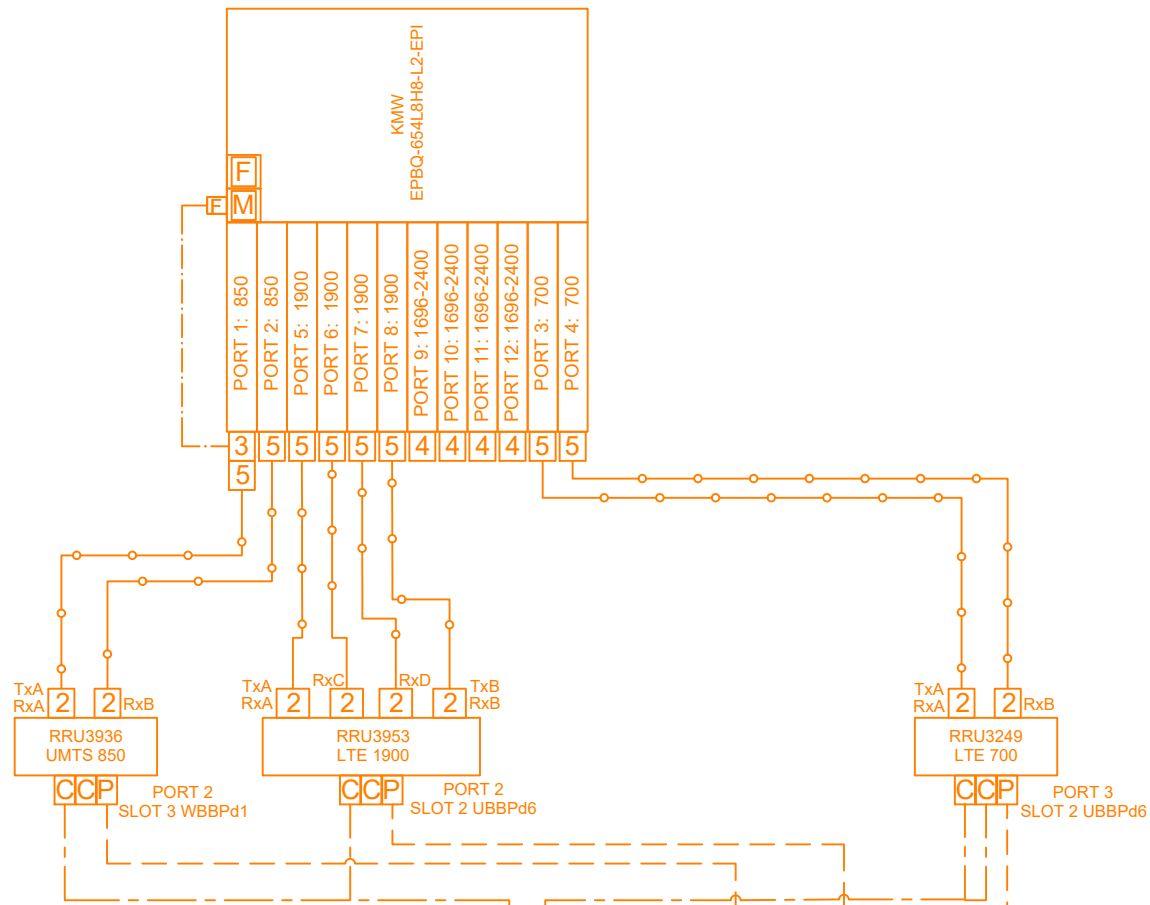


**EQUIPMENT SHARED
FOR ALL SECTORS
BELOW LINE**

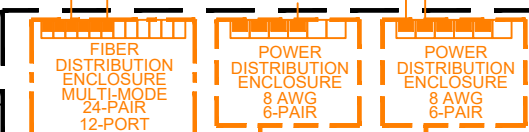

OUTDOOR CONFIGURATION

  INSIDE BUILDING

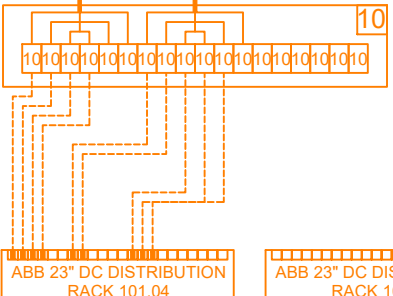

1 R2 RAN CABLING DIAGRAM - BETA SECTOR
SCALE: NO SCALE

LEGEND

- 1/2" JUMPER 4.3-10(M)-DIN(M) - 15
- 1/2" JUMPER 4.3-10(M)-4.3-10(M)
- TRUNK FIBER CABLE - 6 PAIR 3AWG
- ROS FB-L98B-A0303-190FT
- TRUNK POWER CABLE - 6 PAIR 3AWG
- ROS PR-UWPT812-190FT
- TWO PAIR SM FIBER - PLUG N PLAY
- ROS FB-L98B-A0302-7000/10000
- SINGLE PAIR #12 POWER - PLUG N PLAY
- ROS L99-P055-7000/10000
- SINGLE PAIR FIBER CABLE - SM
- SINGLE PAIR POWER CABLE
- (1x) LDF4-50A
- (1x) RET CABLE
- (1x) LMR-400 CABLE
- NEW EQUIPMENT

- 1 GROUND KIT
- 2 1/2" DIN MALE CONNECTOR
- 3 SBT-8F-64-01
- 4 RL-65Z001-000N CAP
- 5 1/2" 4.3-10 MINI DIN MALE CONNECTOR
- 6 APG-BNFFN-350
- 7 LMR-400 N MALE CONNECTOR
- 8 LMR-400 SMA MALE CONNECTOR
- 9 L4TNM-PSA
- 10 RUWCD-2978-P-48
- 11 BA384 ENTRY BOOT KIT
- 12 BA783 ENTRY BOOT KIT
- 13 BA124 ENTRY BOOT KIT
- F FEMALE RET CONNECTOR
- M MALE RET CONNECTOR
- C RRU CPRI PORT
- P RRU POWER PORT

REVIEWED
FOR CODE
COMPLIANCE
11/16/2021



850 N. HIGHWAY 414
PO BOX 160
MOUNTAIN VIEW, WY 82939

THE INFORMATION CONTAINED IN THIS DOCUMENT IS PROPRIETARY. ANY USE OR DISCLOSURE OTHER THAN THOSE AUTHORIZED BY UNION TELEPHONE COMPANY IS STRICTLY PROHIBITED.

CURRENT REV	DATE
G	10/25/2021

DESIGNER: GREG WILLIAMS

REVIEWER: MATT FISHER



APPROVED
FOR
CONSTRUCTION
25 OCTOBER 2021

PROJECT NAME:

HAYDEN

PROJECT ADDRESS:


6985 HOMESTEADER LANE 2
HAYDEN, ROUTT COUNTY, COLORADO

SHEET TITLE:

RAN DIAGRAM - B SECTOR

SHEET NUMBER:


R2

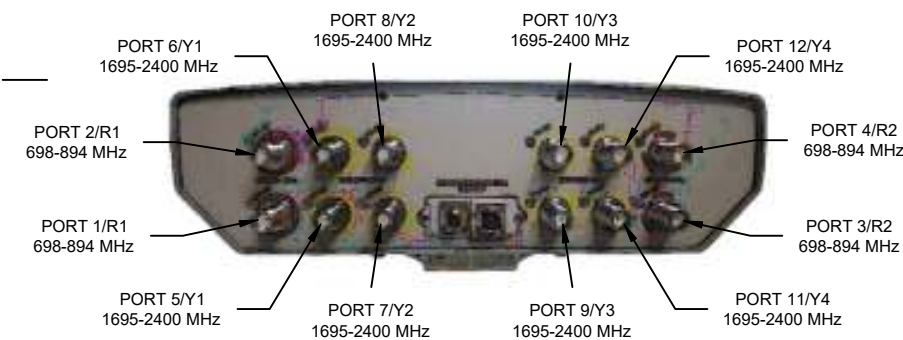

Frequency Range	Array	Connector
880-894MHz	R1	4.3-10 Female
880-894MHz	R2	4.3-10 Female
1895-2400MHz	Y1	4.3-10 Female
1895-2400MHz	Y2	4.3-10 Female
1895-2400MHz	Y3	4.3-10 Female
1895-2400MHz	Y4	4.3-10 Female

SECTOR G4
UMTS 850 F1/F2
LTE 700 2x2
LTE 1900 2x4

KMW
EPBQ-654LH8-L2-EPI

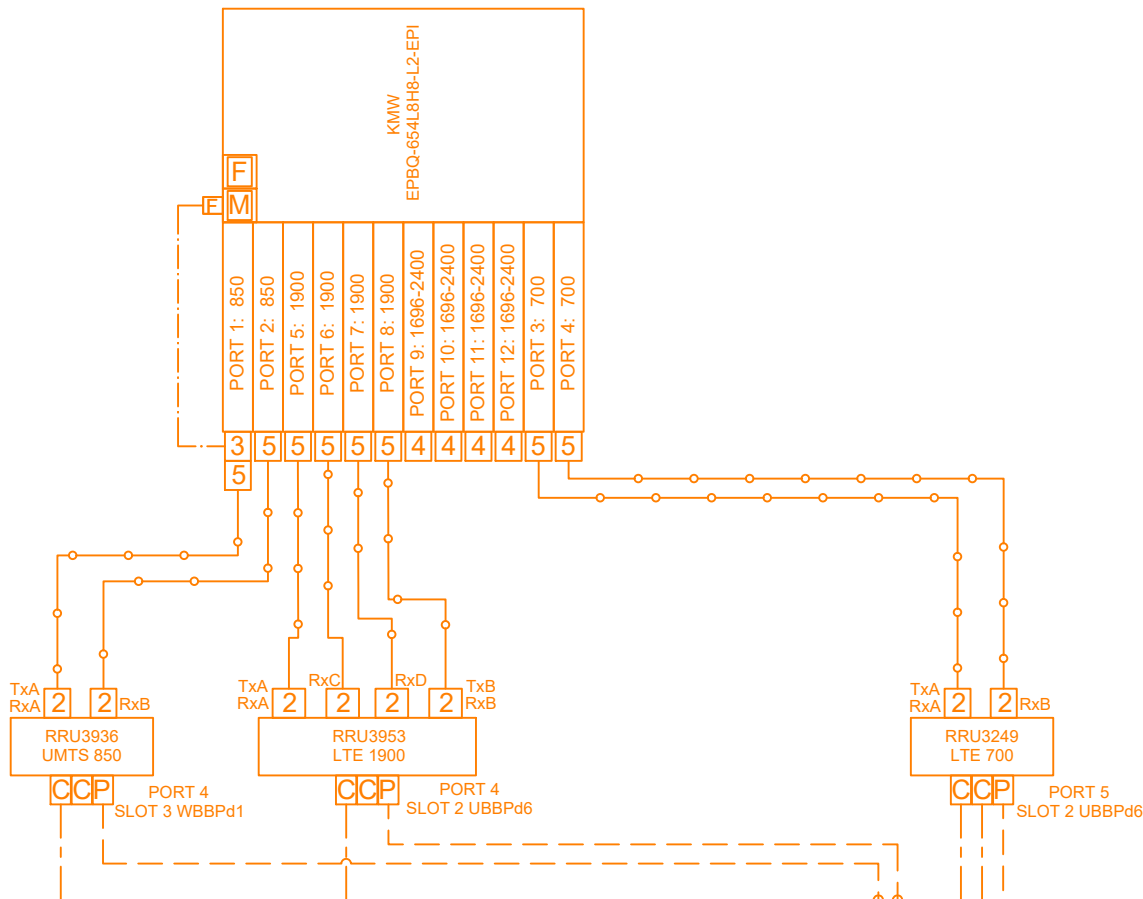

**EQUIPMENT SHARED
FOR ALL SECTORS
BELOW LINE**


OUTDOOR CONFIGURATION

INSIDE BUILDING

CPRI PANEL

BBU CARD

CPRI PANEL - SINGLE MODE

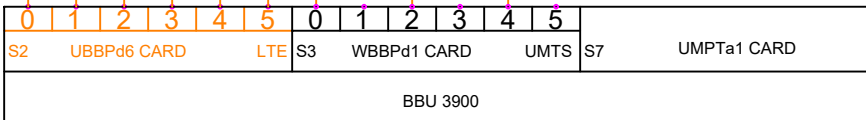

1
R3

RAN CABLING DIAGRAM - GAMMA SECTOR

SCALE: NO SCALE

LEGEND

- 1/2" JUMPER 4.3-10(M)-DIN(M) - 15
- 1/2" JUMPER 4.3-10(M)-4.3-10(M)
- TRUNK FIBER CABLE - 6 PAIR 3AWG
- ROS FB-L98B-A0303-190FT
- TRUNK POWER CABLE - 6 PAIR 3AWG
- ROS PR-UWPT812-190FT
- TWO PAIR SM FIBER - PLUG N PLAY
- ROS FB-L98B-A0302-7000/10000
- SINGLE PAIR #12 POWER - PLUG N PLAY
- ROS L99-P055-7000/10000
- SINGLE PAIR FIBER CABLE - SM
- SINGLE PAIR POWER CABLE
- (1x) LDF4-50A
- (1x) RET CABLE
- (1x) LMR-400 CABLE
- NEW EQUIPMENT

1

GROUND KIT

2

1/2" DIN MALE CONNECTOR

3

SBT-8F-64-01

4

RL-65Z001-000N CAP

5

1/2" 4.3-10 MINI DIN MALE CONNECTOR

6

APG-BNFF-350

7

LMR-400 N MALE CONNECTOR

8

LMR-400 SMA MALE CONNECTOR

9

L4TNM-PSA

10

RUWCD-2978-P-48

11

BA384 ENTRY BOOT KIT

12

BA783 ENTRY BOOT KIT

13

BA124 ENTRY BOOT KIT

F

FEMALE RET CONNECTOR

M

MALE RET CONNECTOR

C

RRU CPRI PORT

P

RRU POWER PORT

REVIEWED
FOR
CODE
COMPLIANCE
11/16/2021



850 N. HIGHWAY 414
PO BOX 160
MOUNTAIN VIEW, WY 82939

THE INFORMATION CONTAINED IN THIS DOCUMENT IS PROPRIETARY. ANY USE OR DISCLOSURE OTHER THAN THOSE AUTHORIZED BY UNION TELEPHONE COMPANY IS STRICTLY PROHIBITED.

CURRENT REV

DATE

G

10/25/2021

DESIGNER:

GREG WILLIAMS

REVIEWER:

MATT FISHER



APPROVED
FOR
CONSTRUCTION

25 OCTOBER 2021

PROJECT NAME:

HAYDEN

PROJECT ADDRESS:


6985 HOMESTEADER LANE 2
HAYDEN, ROUTT COUNTY, COLORADO

SHEET TITLE:

RAN DIAGRAM - G SECTOR

SHEET NUMBER:

R3

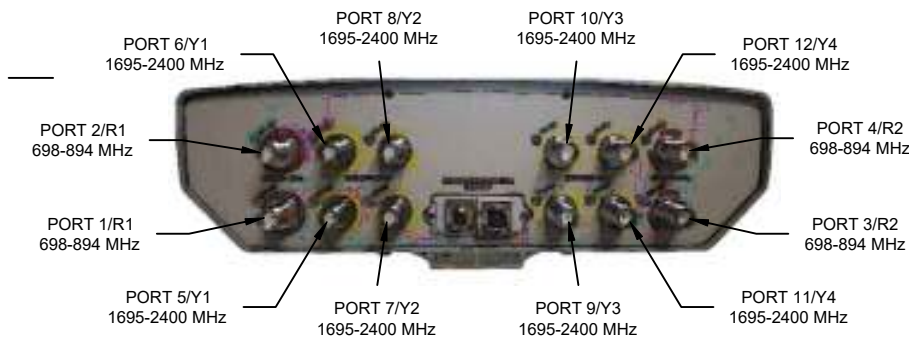

Frequency Range	Array	Connector
800-804MHz	R1	4.3-10 Female
800-804MHz	R2	4.3-10 Female
1895-2400MHz	Y1	4.3-10 Female
1895-2400MHz	Y2	4.3-10 Female
1895-2400MHz	Y3	4.3-10 Female
1895-2400MHz	Y4	4.3-10 Female

MW DISH TO PARACHUTE PEAK
ANDREW USX6-6-W



CERAGON
RFU-HP

8

9

CERAGON
RFU-HP

8

9

9

9

11

8

8

10

10

4

4

4

4

CERAGON IP20A
PCPK

19" RACK - 101.05

REVIEWED
FOR
CODE
COMPLIANCE
11/16/2021

LEGEND

FLEX TWIST

(1X) LDF4-50A

(1X) BW63 WAVEGUIDE

RG-8 COAXIAL

(1X) POWER CABLE

2 PAIR #16 AWG

(1X) SINGLE MODE FIBER

1310nm LC-LC

NEW EQUIPMENT

1

FLEXTWIST ADAPTER

2

E CONNECTOR

3

H CONNECTOR

4

RG8 CONNECTOR

5

SURGE PROTECTOR

6

BAZERO ENTRY BOOT

7

1101-1157 DIN RAIL

7

SURGE PROTECTOR

8

1/2" N-TYPE CONNECTOR

9

1/2" COAX GROUND

10

APG-BNFN-350

11

ENTRY BOOT FOR 1/2" COAX

O

OPTICAL PORT

P

 
W/ GIG ETH SFP

P

POWER PORT

L

TERMINATION LOAD



ENTRY PANEL

GROUND BAR

850 N. HIGHWAY 414
PO BOX 160
MOUNTAIN VIEW, WY 82939

THE INFORMATION CONTAINED IN THIS DOCUMENT IS PROPRIETARY. ANY USE OR DISCLOSURE OTHER THAN THOSE AUTHORIZED BY UNION TELEPHONE COMPANY IS STRICTLY PROHIBITED.

CURRENT REV	DATE
G	10/25/2021

DESIGNER:
GREG WILLIAMS

REVIEWER:
MATT FISHER

APPROVED
FOR
CONSTRUCTION
25 OCTOBER 2021

PROJECT NAME:
HAYDEN

PROJECT ADDRESS:
6985 HOMESTEADER LANE 2
HAYDEN, ROUTT COUNTY, COLORADO

SHEET TITLE:
MICROWAVE CONFIGURATION


SHEET NUMBER:
R4

LEGEND


NEW EQUIPMENT

RETIRE EQUIPMENT

NOTE:
STRUCTURAL AND MOUNT
ANALYSIS BY OTHERS.

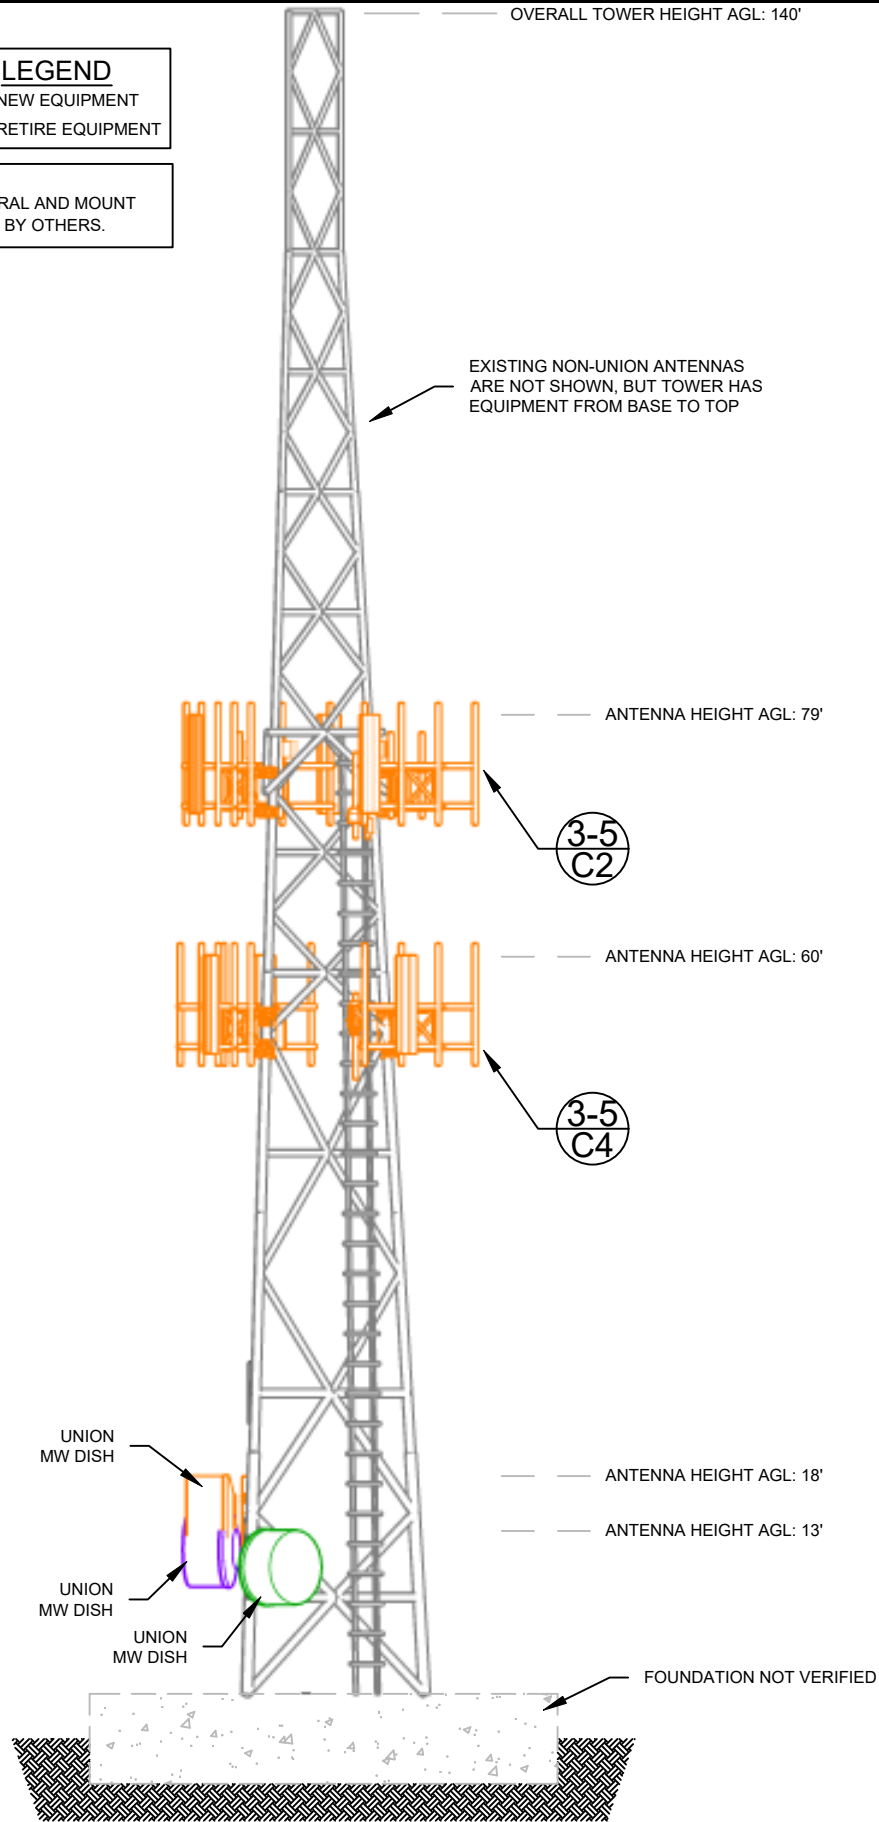

1 SOUTH FACE ELEVATION
SCALE: 1/16"=1'

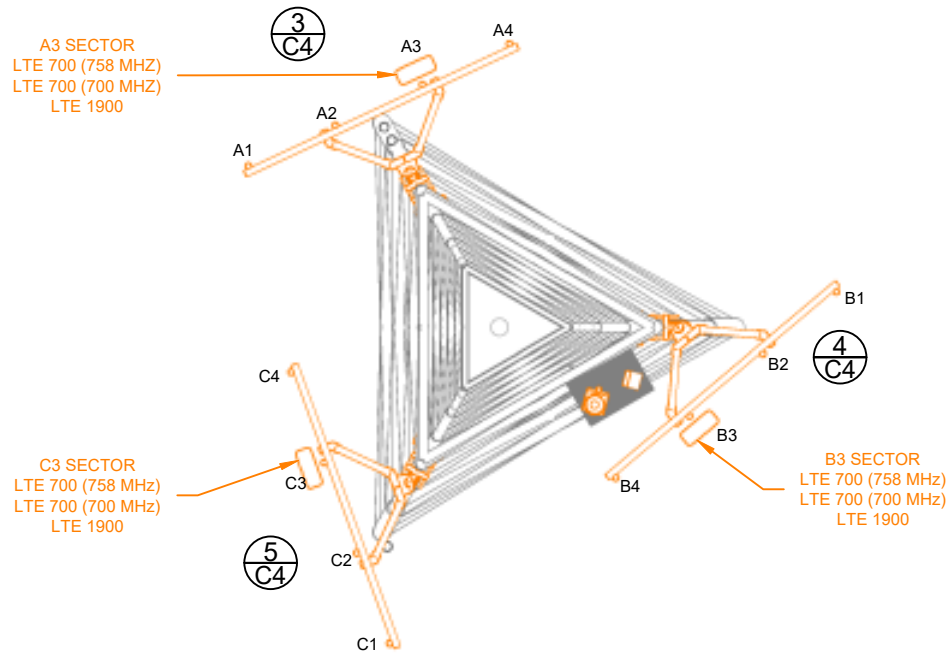

2 FN ANTENNA DETAILS
SCALE: 1/8"=1'

3 ANT FRAME DETAILS

A3 SECTOR	ANTENNA MANUFACTURER & MODEL:	1X COMMSCOPE NNH4-65C-R6-V3 OR SIMILAR
	AZIMUTH:	326° MAG (335° TRUE)
	TIP HEIGHT ABOVE GROUND LEVEL:	60'
	TECHNOLOGY FOR 698-896 MHz PORTS:	LTE 7A_1_FA/7A_2_A
	DOWNTILT FOR 698-896 MHz:	0°MECH, RET (SEE RFDS)
	WAVEGUIDE SPECS FOR 698-896 MHz:	(4) LDF4-50A
	TECHNOLOGY FOR 1695-2360 MHz PORTS:	LTE 9A_1_A
	DOWNTILT FOR 1695-2360 MHz:	0°MECH, RET (SEE RFDS)
B3 SECTOR	WAVEGUIDE SPECS FOR 1695-2360 MHz:	(4) LDF4-50A, (4) PORTS CAPPED


4 ANT FRAME DETAILS

B3 SECTOR	ANTENNA MANUFACTURER & MODEL:	1X COMMSCOPE NNH4-65C-R6-V3 OR SIMILAR
	AZIMUTH:	131° MAG (140° TRUE)
	TIP HEIGHT ABOVE GROUND LEVEL:	60'
	TECHNOLOGY FOR 698-896 MHz PORTS:	LTE 7B_1_FA/7B_2_A
	DOWNTILT FOR 698-896 MHz:	0°MECH, RET (SEE RFDS)
	WAVEGUIDE SPECS FOR 698-896 MHz:	(4) LDF4-50A
	TECHNOLOGY FOR 1695-2360 MHz PORTS:	LTE 9B_1_A
	DOWNTILT FOR 1695-2360 MHz:	0°MECH, RET (SEE RFDS)
C3 SECTOR	WAVEGUIDE SPECS FOR 1695-2360 MHz:	(4) LDF4-50A, (4) PORTS CAPPED

5 ANT FRAME DETAILS

C3 SECTOR	ANTENNA MANUFACTURER & MODEL:	1X COMMSCOPE NNH4-65C-R6-V3 OR SIMILAR
	AZIMUTH:	241° MAG (250° TRUE)
	TIP HEIGHT ABOVE GROUND LEVEL:	60'
	TECHNOLOGY FOR 698-896 MHz PORTS:	LTE 7C_1_FA/7C_2_A
	DOWNTILT FOR 698-896 MHz:	0°MECH, RET (SEE RFDS)
	WAVEGUIDE SPECS FOR 698-896 MHz:	(4) LDF4-50A
	TECHNOLOGY FOR 1695-2360 MHz PORTS:	LTE 9C_1_A
	DOWNTILT FOR 1695-2360 MHz:	0°MECH, RET (SEE RFDS)
B3 SECTOR	WAVEGUIDE SPECS FOR 1695-2360 MHz:	(4) LDF4-50A, (4) PORTS CAPPED

 REVIEWED
FOR
CODE
COMPLIANCE
11/16/2021



850 N. HIGHWAY 414
PO BOX 160
MOUNTAIN VIEW, WY 82939

THE INFORMATION CONTAINED IN THIS DOCUMENT IS PROPRIETARY. ANY USE OR DISCLOSURE OTHER THAN THOSE AUTHORIZED BY UNION TELEPHONE COMPANY IS STRICTLY PROHIBITED.

CURRENT REV	DATE
G	10/25/2021

DESIGNER:
GREG WILLIAMS

REVIEWER:
MATT FISHER



APPROVED
FOR
CONSTRUCTION
25 OCTOBER 2021

AT&T SITE ID:
COL04472A


FA CODE:
15084276

PROJECT NAME:
HAYDEN

PROJECT ADDRESS:
6985 HOMESTEADER LANE 2
HAYDEN, ROUTT COUNTY, COLORADO


SHEET TITLE:
FN ANTENNA DETAILS

SHEET NUMBER:
C4

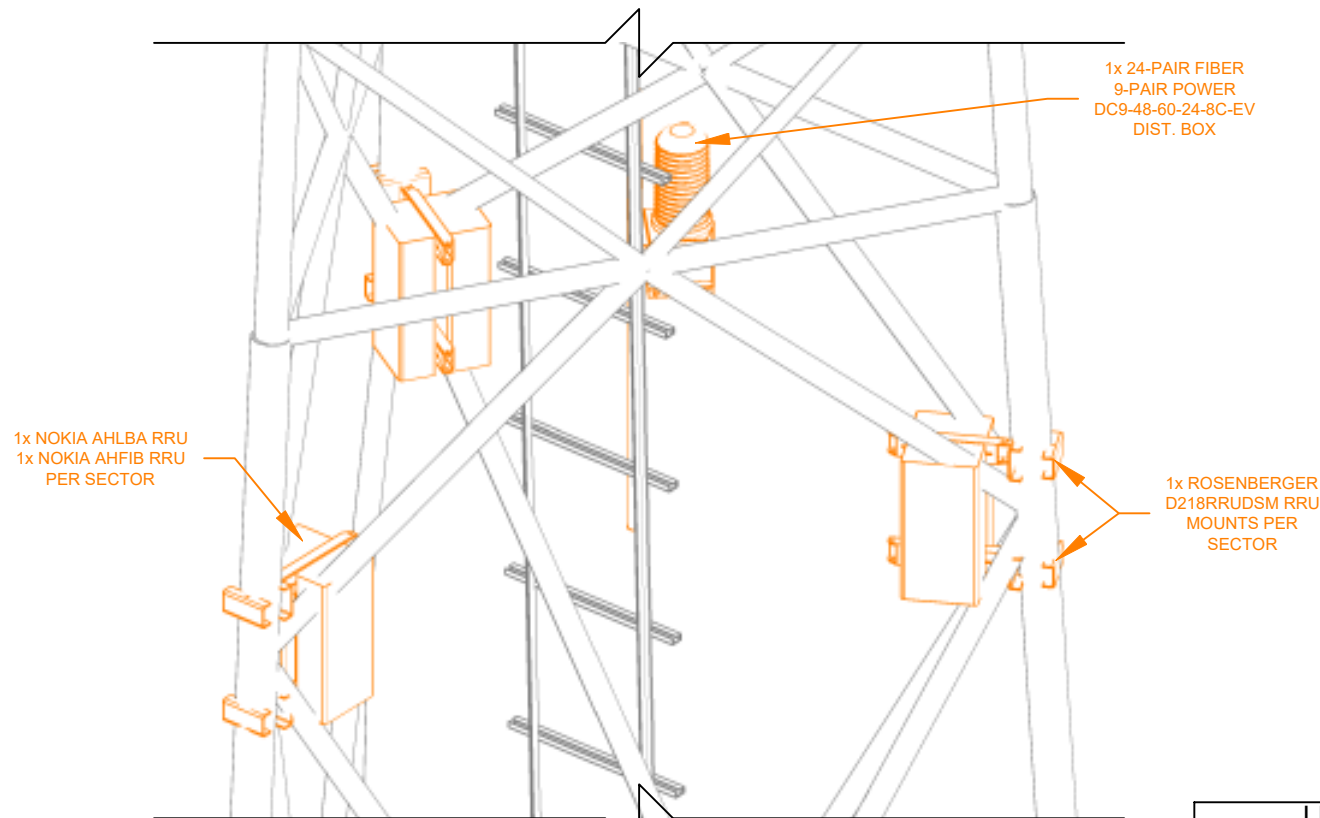


1 RRU MOUNT PERSPECTIVE
C7 SCALE: 3/8"=1'


LEGEND	
	NEW/CHANGED EQUIPMENT
	RETIRE EQUIPMENT

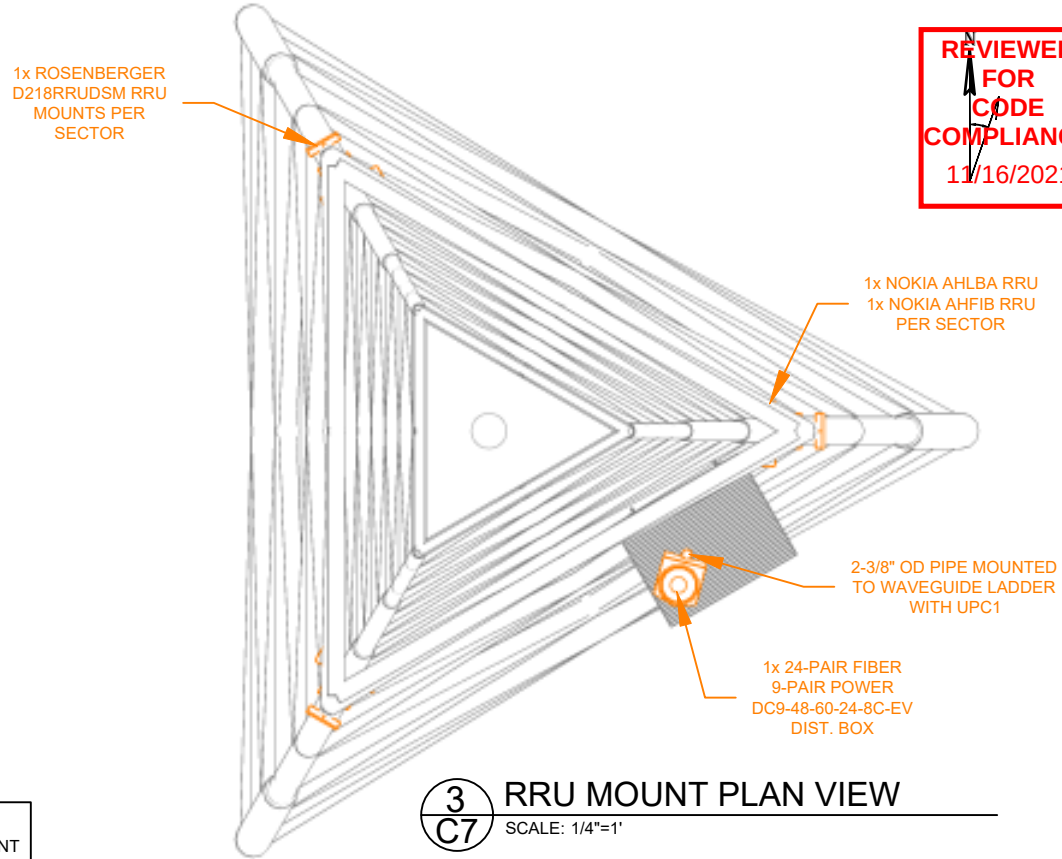

3 RRU MOUNT PLAN VIEW
C7 SCALE: 1/4"=1'

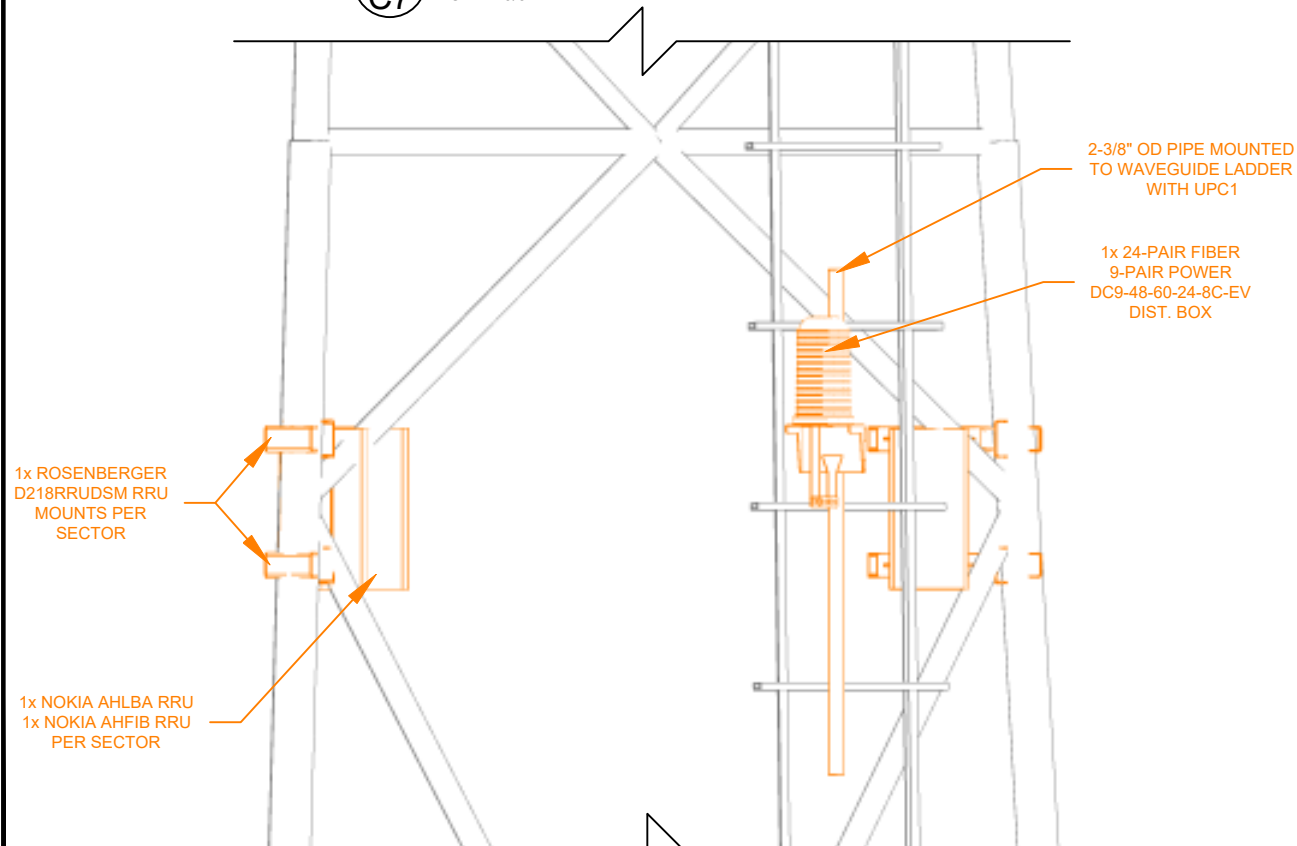

2 RRU ELEVATION VIEW
C7 SCALE: 3/8"=1'

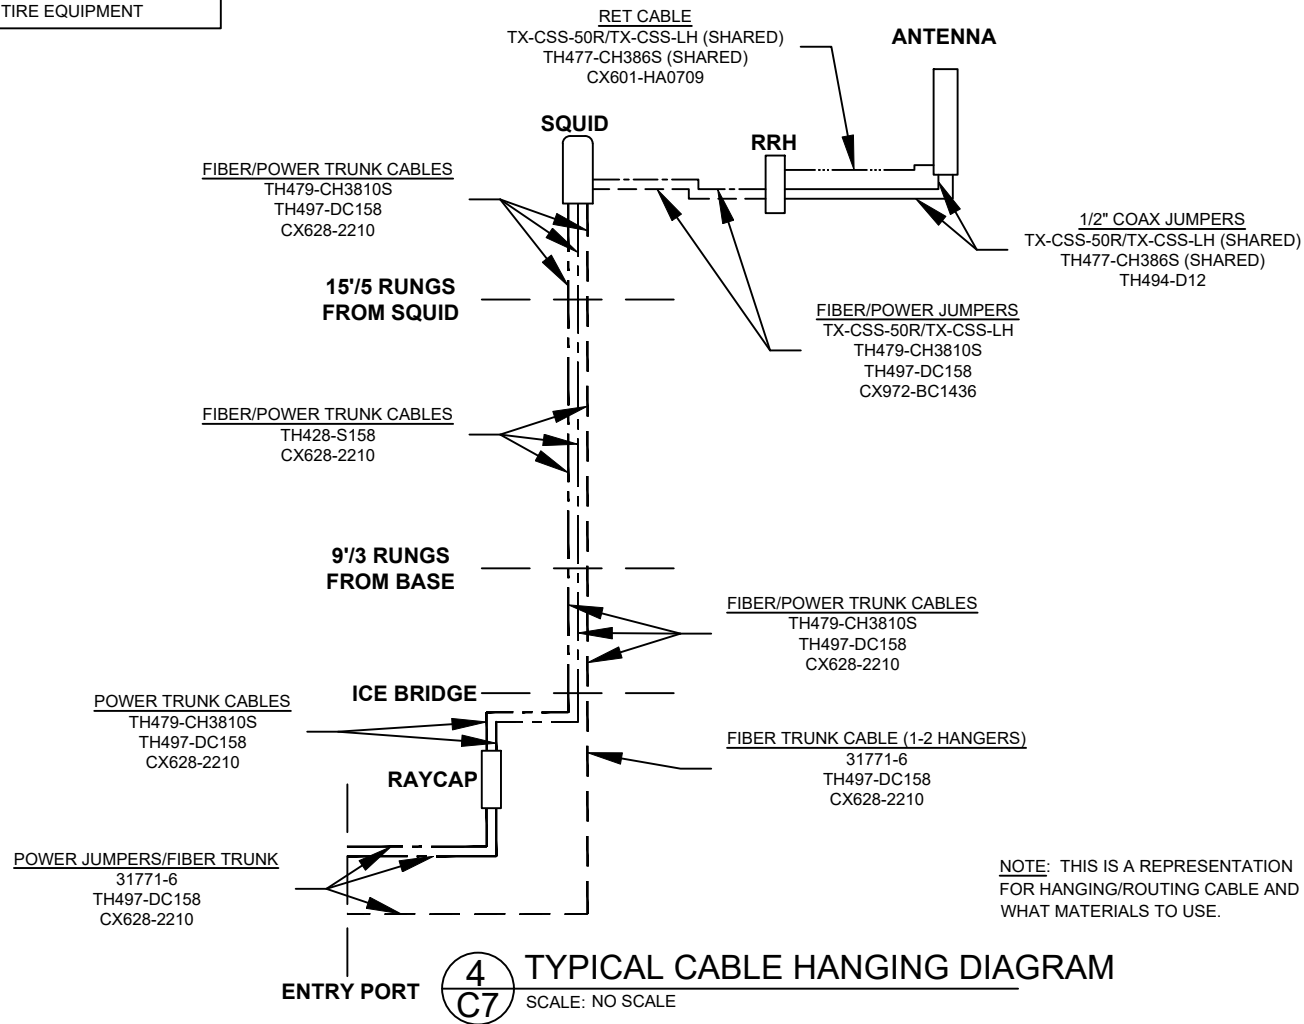

4 TYPICAL CABLE HANGING DIAGRAM
C7 SCALE: NO SCALE

REVIEWED
FOR
CODE
COMPLIANCE
11/16/2021



850 N. HIGHWAY 414
PO BOX 160
MOUNTAIN VIEW, WY 82939

THE INFORMATION CONTAINED IN THIS DOCUMENT IS PROPRIETARY. ANY USE OR DISCLOSURE OTHER THAN THOSE AUTHORIZED BY UNION TELEPHONE COMPANY IS STRICTLY PROHIBITED.

CURRENT REV	DATE
G	10/25/2021

DESIGNER:
GREG WILLIAMS

REVIEWER:
MATT FISHER



APPROVED
FOR
CONSTRUCTION
25 OCTOBER 2021

AT&T SITE ID:
COL04472A

FA CODE:
15084276

PROJECT NAME:
HAYDEN

PROJECT ADDRESS:
6985 HOMESTEADER LANE 2
HAYDEN, ROUTT COUNTY, COLORADO

SHEET TITLE:
FN RRU MOUNT DETAILS


SHEET NUMBER:
C7

1 Power Cable Configuration - Squid

R6 SCALE: NO SCALE

POWER CABLE LAYOUT					
Power Squid					
Port	Sector	Frequency Band	Trunk Cable - Tape Requirement	Cable Stripe Color (Inside Keycap)	Power Jumper between Squid and RRU
A3	A	700	Red	Green	Red/Blue
A7	A	PCS/AWS	Red	Orange	Red/Yel w/ PCS / White AWS
A1	A	Spare	Red	Blue	
B3	B	700	Blue	Green	Blue/Blue
B2	B	PCS/AWS	Blue	Orange	Blue/Yel w/ PCS / White AWS
B1	B	Spare	Blue	Blue	
C7	C	700	Green	Green	Green/Blue
C1	C	PCS/AWS	Green	Orange	Green/Yel w/ PCS / White AWS
C1	C	Spare	Green	Blue	

** BOTH AWS AND PCS PRESENT AT THE W-1E **

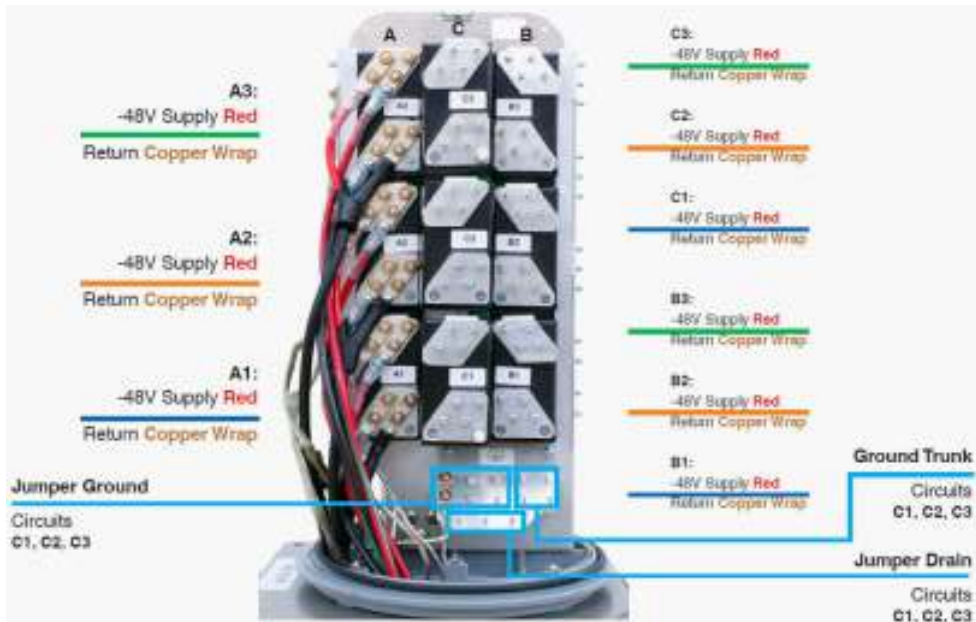

Squid Power Configuration

3 Power Cable Configuration - DC12

R6 SCALE: NO SCALE

DC12				
Port	Sector	Frequency Band	Trunk Cable - Tape Requirement	Cable Stripe Color (Inside Keycap)
A1	A	Spare	Red	Blue
A2	A	PCS/AWS	Red	Orange
A3	A	700	Red	Green
B1	B	Spare	Blue	Blue
B2	B	PCS/AWS	Blue	Orange
B3	B	700	Blue	Green
C1	C	Spare	Green	Blue
C2	C	PCS/AWS	Green	Orange
C3	C	700	Green	Green
D1	D	N/A	N/A	N/A
D2	D	N/A	N/A	N/A
D3	D	N/A	N/A	N/A

** Note **

ONLY 4 OF PORTS IN DC12 IS HIRED FROM HAYDEN SQUID

2 Fiber Cable Configuration

R6 SCALE: NO SCALE

FIBER LAYOUT				
Fiber Pair	Sector	Frequency Band	Jumper between Squid & RRU (see Requirement)	Trunk Cable - Tape Requirement
1	A	700 - Optical 1	Red/Blue/Red	
2	A	700 - Optical 2	Red/Blue/Blue	
3	A	PCS/AWS - Optical 1	Red/Yel w/ White/Red	
4	A	PCS/AWS - Optical 2	Red/Yel w/ White/Blue	
5	A	Spare	r/a	
6	A	Spare	r/a	
7	B	700 - Optical 1	Blue/Blue/Red	
8	B	700 - Optical 2	Blue/Blue/Blue	
9	B	PCS/AWS - Optical 1	Blue/Yel w/ White/Red	
10	B	PCS/AWS - Optical 2	Blue/Yel w/ White/Blue	
11	B	Spare	r/a	
12	B	Spare	r/a	
13	C	700 - Optical 1	Green/Blue/Red	
14	C	700 - Optical 2	Green/Blue/Blue	
15	C	PCS/AWS - Optical 1	Green/Yel w/ White/Red	
16	C	PCS/AWS - Optical 2	Green/Yel w/ White/Blue	
17	C	Spare	r/a	
18	C	Spare	r/a	
19	C	Spare	r/a	
20	C	Spare	r/a	
21	C	Spare	r/a	
22	C	Spare	r/a	
23	C	Spare	r/a	
24	C	Spare	r/a	

** Yellow tape indicates PCS **

** White tape indicates AWS **



Squid Fiber Configuration


4 RET Cable Configuration - RRU

R6 SCALE: NO SCALE

RET		
Sector	Frequency Band	RET
A	700	Red/Blue
	AWS	1/2
	PCS	1/2
B	700	Blue/Blue
	AWS	1/2
	PCS	1/2
C	700	Green/Blue
	AWS	1/2
	PCS	1/2



DC12-48-60-0-25E Port Layout

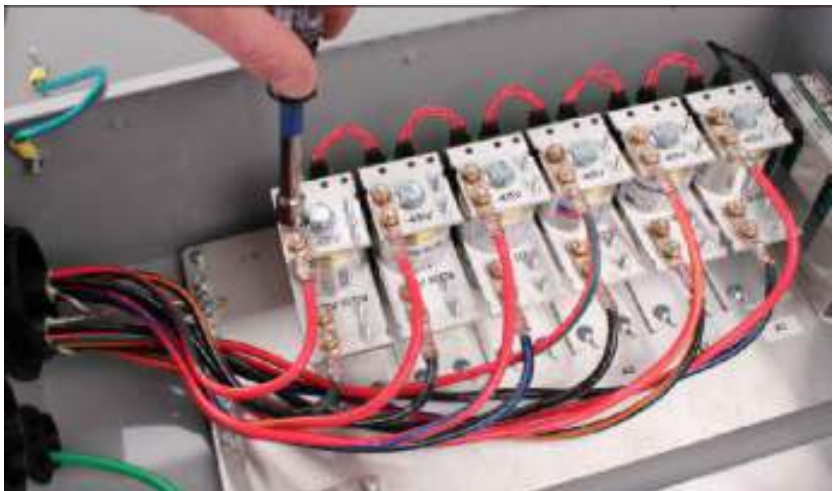

DC12-48-60-0-25E Port Configuration



850 N. HIGHWAY 414
PO BOX 160
MOUNTAIN VIEW, WY 82939

THE INFORMATION CONTAINED IN THIS DOCUMENT IS PROPRIETARY. ANY USE OR DISCLOSURE OTHER THAN THOSE AUTHORIZED BY UNION TELEPHONE COMPANY IS STRICTLY PROHIBITED.

CURRENT REV	DATE
G	10/25/2021

DESIGNER: GREG WILLIAMS

REVIEWER: MATT FISHER



APPROVED
FOR
CONSTRUCTION
25 OCTOBER 2021

AT&T SITE ID: COL04472A

FA CODE: 15084276

PROJECT NAME: HAYDEN

PROJECT ADDRESS: 6985 HOMESTEADER LANE 2
HAYDEN, ROUTT COUNTY, COLORADO

SHEET TITLE: FN ARRESTOR DIST. LAYOUT

SHEET NUMBER: R6

GROUND ROD CONNECTION

GROUNDING CONNECTORS

TOWER GROUND CONNECTOR

GR

GROUND ROD - 10"x5/8" OD

GROUND BAR (GB-0424-IS OR SIMILAR)

SOLID #2 AWG TINNED COPPER WIRE - BEND RADIUS NOT TO BE LESS THAN 12"

STRANDED #2 AWG COPPER WIRE - GREEN INSULATED

STRANDED #6 AWG COPPER WIRE - GREEN INSULATED

#6 AWG ONE HOLE LUG (YA6CL3BOX)

#2 AWG LUG (YA2C2TC38)

1-5/8" COAXIAL CABLE - AVA7-50

1/2" COAXIAL CABLE - LDF4-50A

24-PAIR SINGLE MODE TRUCK FIBER CABLE

6-PAIR #8 AWG TRUCK POWER CABLE

FN 24-PAIR SINGLE MODE TRUNK FIBER CABLE

FN 3-PAIR #8 AWG TRUCK POWER CABLE

NEW EQUIPMENT

1

G1

GROUNDING DIAGRAM

SCALE: NO SCALE

REVIEWED
FOR
CODE
COMPLIANCE
11/16/2021

850 N. HIGHWAY 414
PO BOX 160
MOUNTAIN VIEW, WY 82939

THE INFORMATION CONTAINED IN THIS DOCUMENT IS PROPRIETARY. ANY USE OR DISCLOSURE OTHER THAN THOSE AUTHORIZED BY UNION TELEPHONE COMPANY IS STRICTLY PROHIBITED.

CURRENT REV	DATE
A	10/25/2021

DESIGNER:
GREG WILLIAMS

REVIEWER:
MATT FISHER

APPROVED
FOR
CONSTRUCTION
25 OCTOBER 2021

AT&T SITE ID:
COL04472A


FA CODE:
15084276

PROJECT NAME:
HAYDEN


PROJECT ADDRESS:
6985 HOMESTEADER LANE 2
HAYDEN, ROUTT COUNTY, COLORADO

SHEET TITLE:
FN GROUNDING PLAN VIEW

SHEET NUMBER:
G1

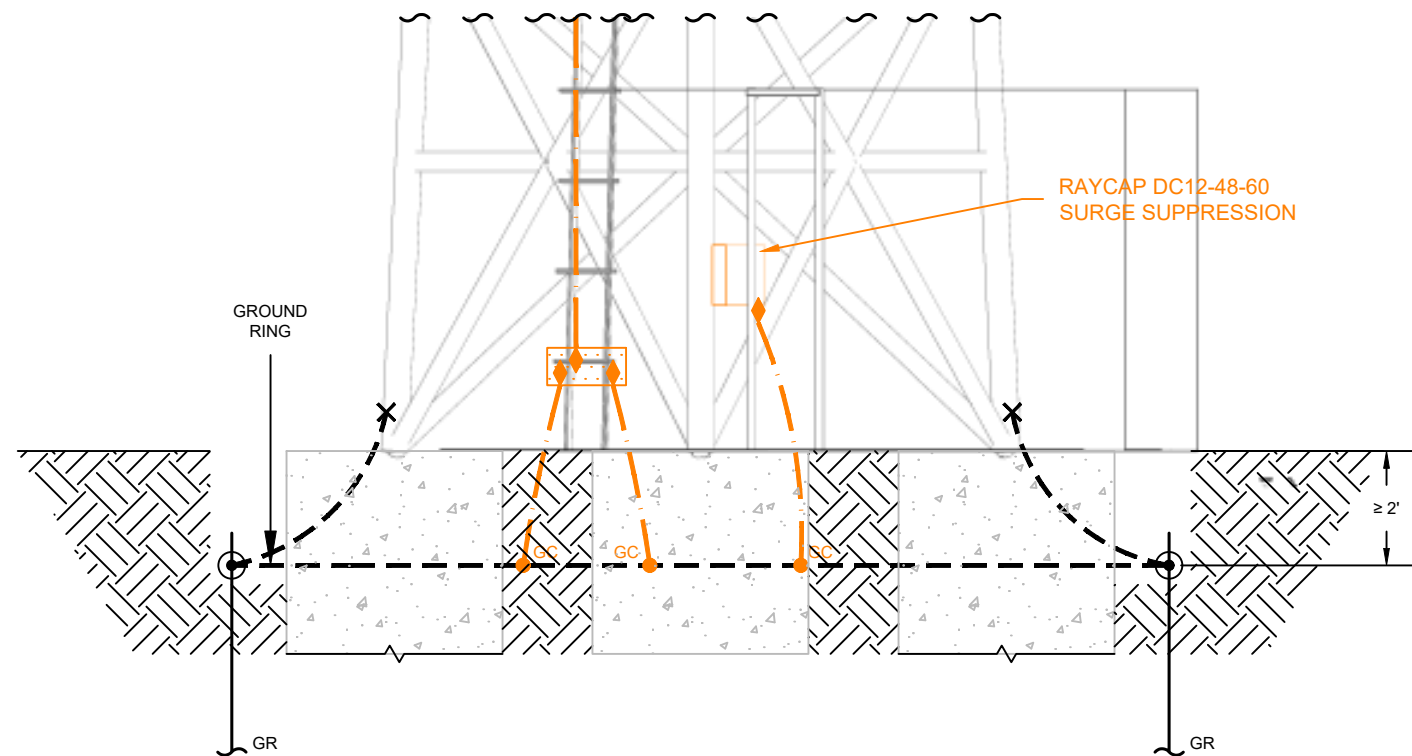

1
G2 TOWER GROUNDING ELEVATION
SCALE: NO SCALE

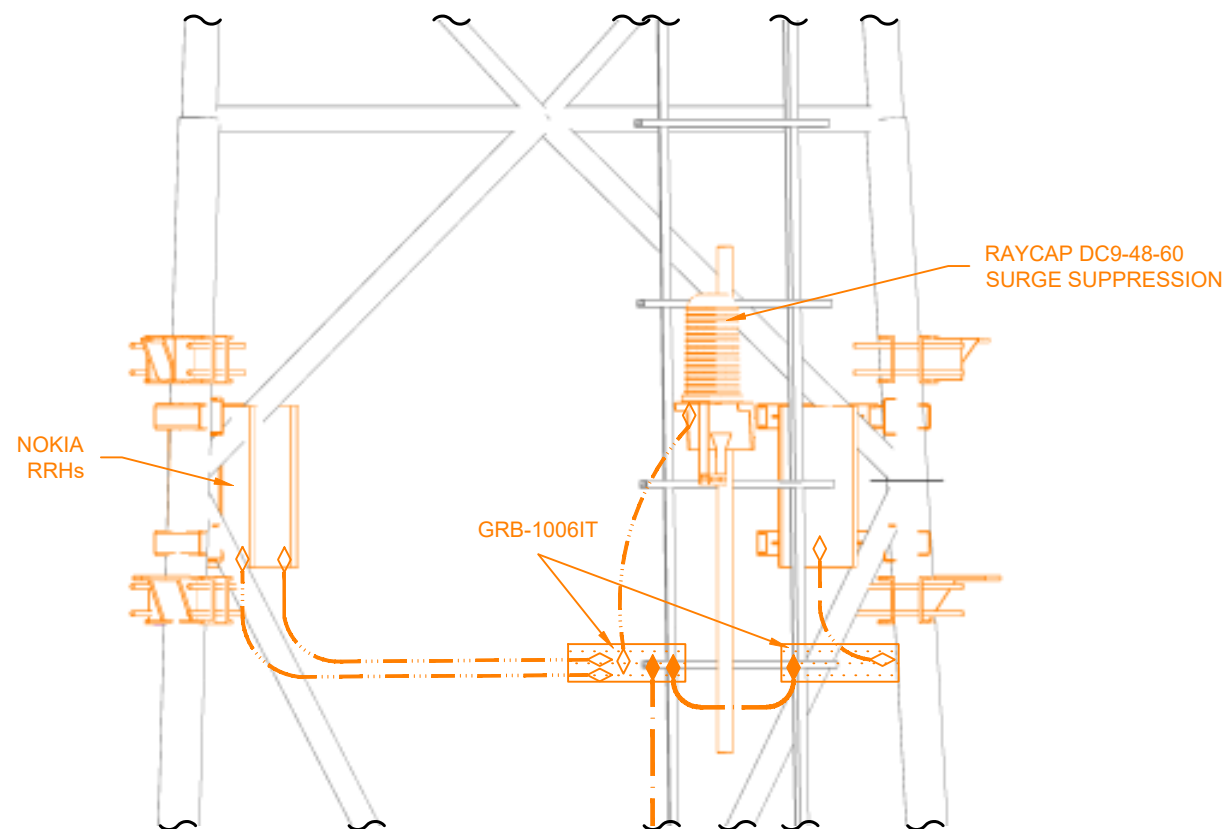


2
G2 TOWER GROUNDING ELEVATION
SCALE: NO SCALE


LEGEND

- ⊙ GROUND ROD CONNECTION
- GROUNDING CONNECTORS
- ✕ TOWER GROUND CONNECTOR
- GR GROUND ROD - 10'x5/8" OD
- ▨ GROUND BAR (GB-0424-IS OR SIMILAR)
- SOLID #2 AWG TINNED COPPER WIRE - BEND RADIUS NOT TO BE LESS THAN 12"
- STRANDED #2 AWG COPPER WIRE - GREEN INSULATED
- STRANDED #6 AWG COPPER WIRE - GREEN INSULATED
- ◇ #6 AWG ONE HOLE LUG (YA6CL3BOX)
- ◆ #2 AWG LUG (YA2C2TC38)
- ⑨ EW90 WAVEGUIDE
- ⑥ EW63 WAVEGUIDE
- ⑤ 7/8" COAXIAL CABLE
- ④ 1/2" COAXIAL CABLE
- ⊗ CAT6 - OUTDOOR RATED
- ⊕ SINGLE PAIR MULTI-MODE FIBER JUMPERS
- SINGLE PAIR #12 AWG POWER JUMPERS
- ① FN 24-PAIR SINGLE MODE TRUNK FIBER CABLE
- ⊕ FN 3-PAIR #8 AWG TRUCK POWER CABLE
- NEW EQUIPMENT

**REVIEWED
FOR
CODE
COMPLIANCE**
11/16/2021

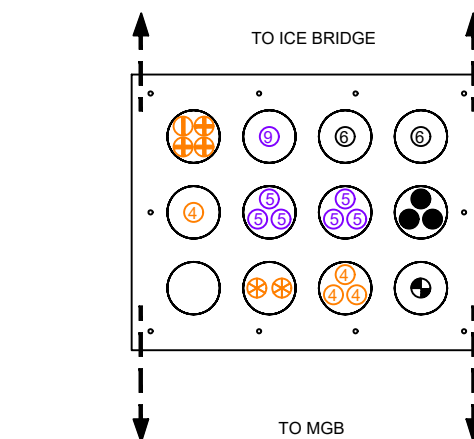

3
G2 EPANEL CONFIGURATION
SCALE: NO SCALE

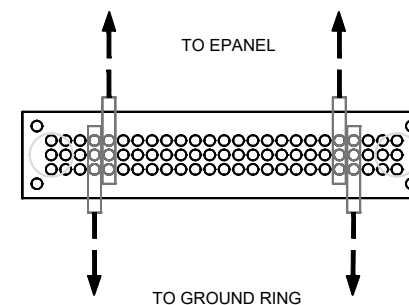

4
G2 MAIN GROUND BUS - BUILDING
SCALE: NO SCALE

850 N. HIGHWAY 414
PO BOX 160
MOUNTAIN VIEW, WY 82939

THE INFORMATION CONTAINED IN THIS DOCUMENT IS PROPRIETARY. ANY USE OR DISCLOSURE OTHER THAN THOSE AUTHORIZED BY UNION TELEPHONE COMPANY IS STRICTLY PROHIBITED.

CURRENT REV	DATE
A	10/25/2021

DESIGNER: **GREG WILLIAMS**

REVIEWER: **MATT FISHER**

APPROVED
FOR
CONSTRUCTION

25 OCTOBER 2021

AT&T SITE ID: **COL04472A**

FA CODE: **15084276**

PROJECT NAME: **HAYDEN**

PROJECT ADDRESS:
6985 HOMESTEADER LANE 2
HAYDEN, ROUTT COUNTY, COLORADO


SHEET TITLE:
FN GROUNDING DIAGRAMS

SHEET NUMBER: **G2**


LEGEND

NEW EQUIPMENT


RETIRE EQUIPMENT

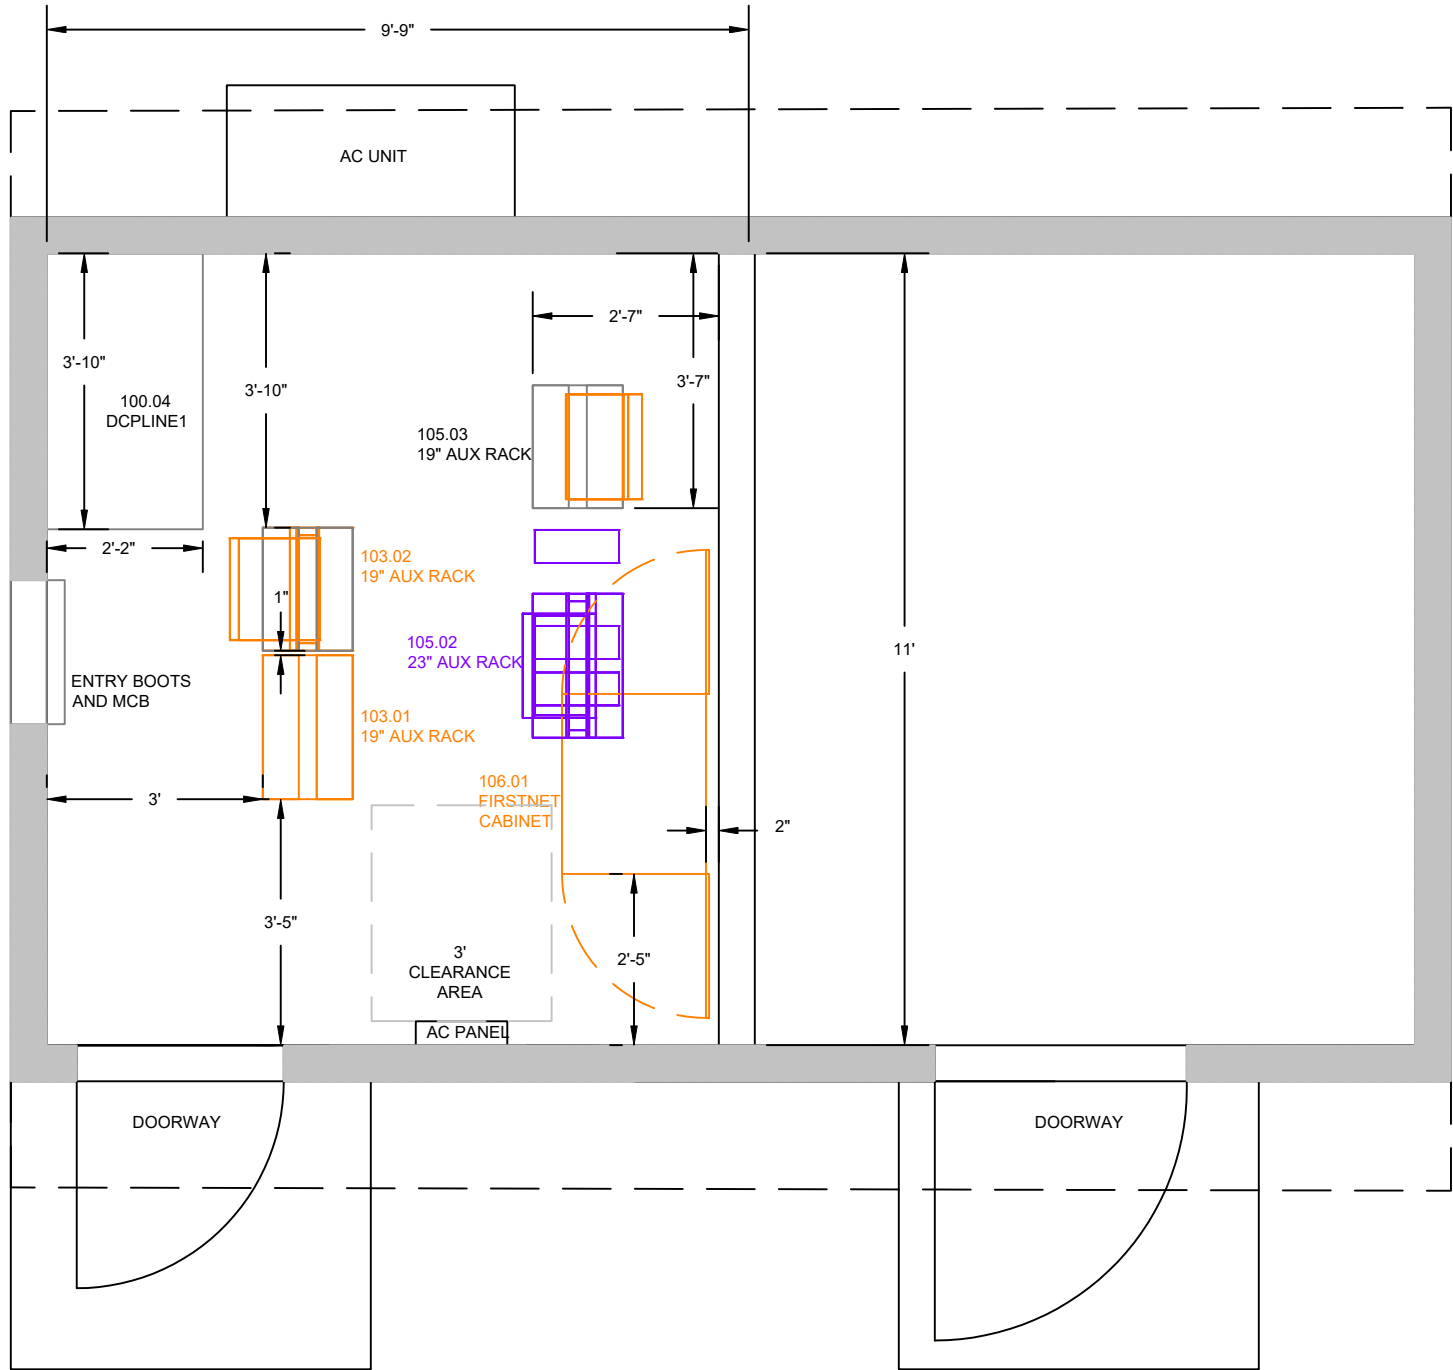

1
A1 COMMUNICATION SITE FLOOR PLAN
SCALE: 3"=8'

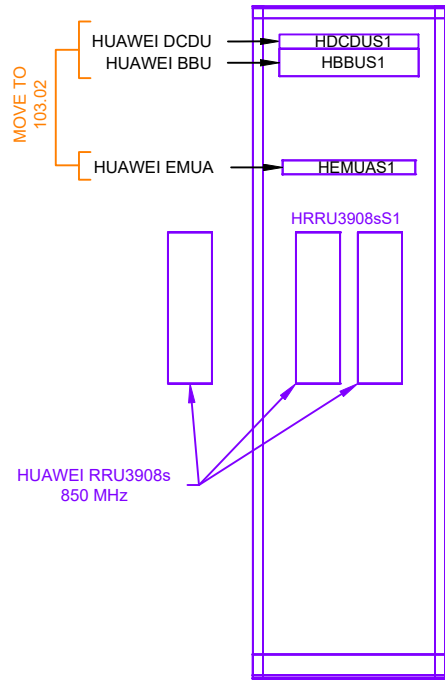


2
A1 105.02 - 23" AUX RACK
SCALE: 1"=2'

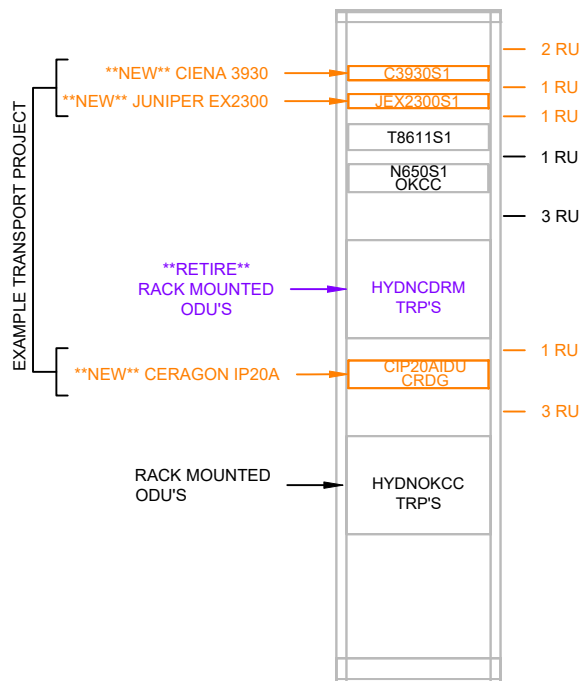

3
A1 105.03 - 19" AUX RACK
SCALE: 1"=2'

NOTE: PLEASE PROVIDE HEIGHT MEASUREMENTS IN AS BUILTS

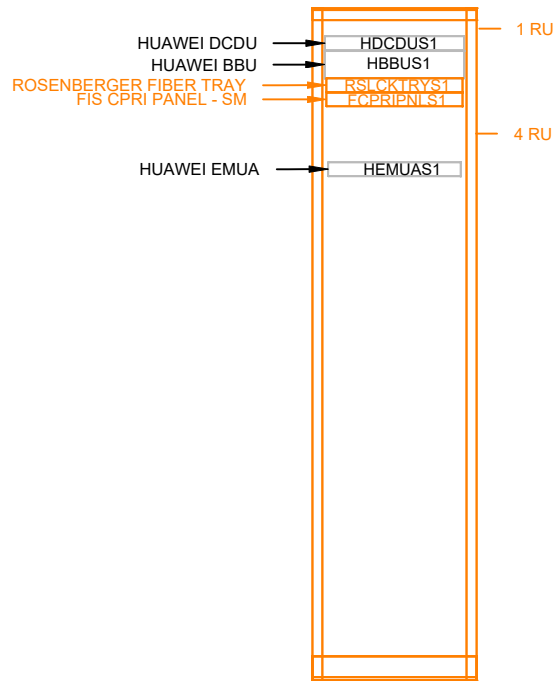

4
A1 103.02 - 19" AUX RACK
SCALE: 1"=2'

NOTE: PLEASE PROVIDE HEIGHT MEASUREMENTS IN AS BUILTS

REVIEWED
FOR
CODE
COMPLIANCE
11/16/2021



850 N. HIGHWAY 414
PO BOX 160
MOUNTAIN VIEW, WY 82939

THE INFORMATION CONTAINED IN THIS DOCUMENT IS PROPRIETARY. ANY USE OR DISCLOSURE OTHER THAN THOSE AUTHORIZED BY UNION TELEPHONE COMPANY IS STRICTLY PROHIBITED.

CURRENT REV	DATE
C	10/25/2021

DESIGNER:
GREG WILLIAMS

REVIEWER:
MATT FISHER



APPROVED
FOR
CONSTRUCTION
25 OCTOBER 2021

PROJECT NAME:
HAYDEN

PROJECT ADDRESS:
6985 HOMESTEADER LANE 2
HAYDEN, ROUTT COUNTY, COLORADO




SHEET TITLE:
EQUIPMENT
BUILDING LAYOUT

SHEET NUMBER:
A1

LEGEND

NEW EQUIPMENT

RETIRE EQUIPMENT

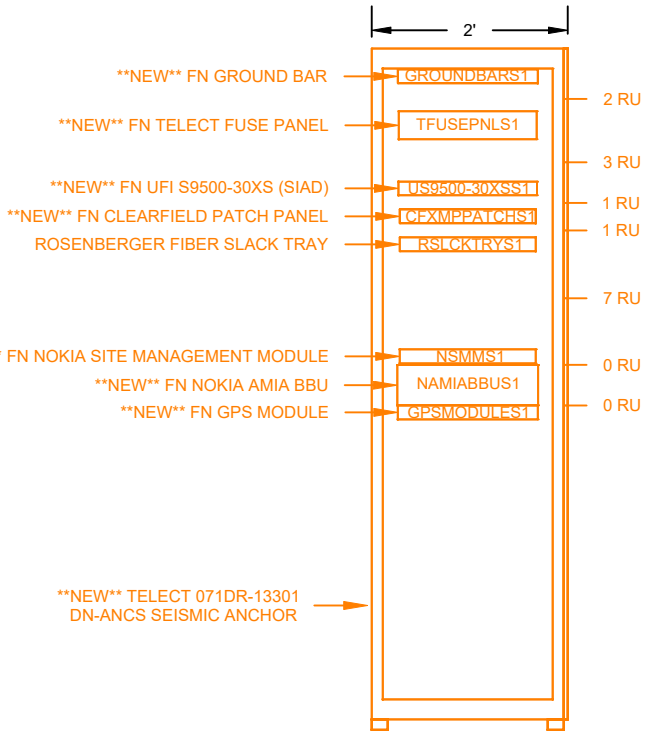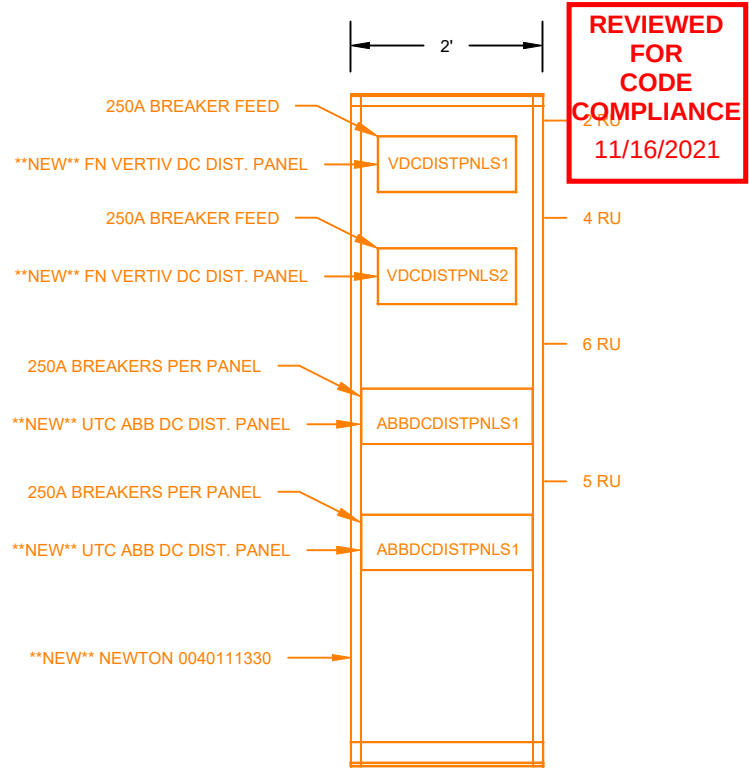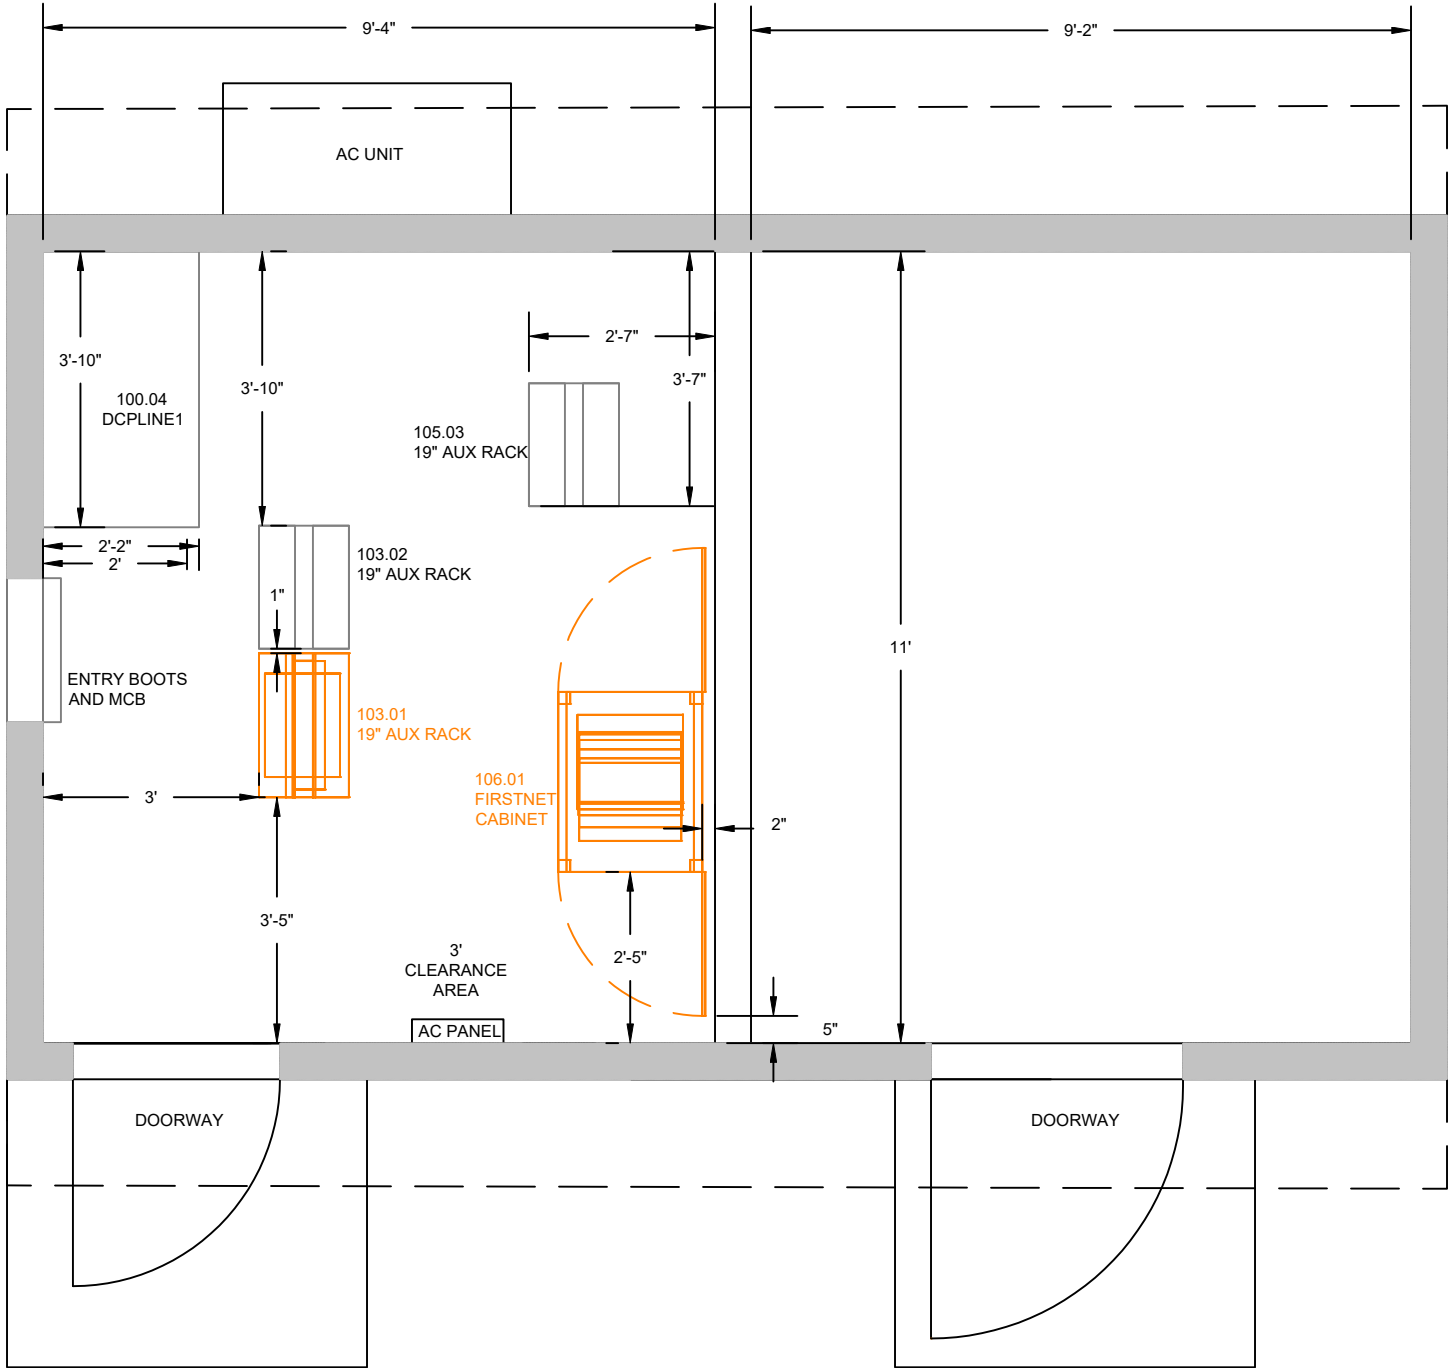

850 N. HIGHWAY 414
PO BOX 160
MOUNTAIN VIEW, WY 82939

THE INFORMATION CONTAINED IN THIS DOCUMENT IS PROPRIETARY. ANY USE OR DISCLOSURE OTHER THAN THOSE AUTHORIZED BY UNION TELEPHONE COMPANY IS STRICTLY PROHIBITED.

CURRENT REV	DATE
C	10/25/2021

DESIGNER:
GREG WILLIAMS

REVIEWER:
MATT FISHER



APPROVED
FOR
CONSTRUCTION

25 OCTOBER 2021

AT&T SITE ID:
COL04472A

FA CODE:
15084276

PROJECT NAME:
HAYDEN

PROJECT ADDRESS:
6985 HOMESTEADER LANE 2
HAYDEN, ROUTT COUNTY, COLORADO

SHEET TITLE:
FN EQUIPMENT
BUILDING LAYOUT

SHEET NUMBER:
A2