


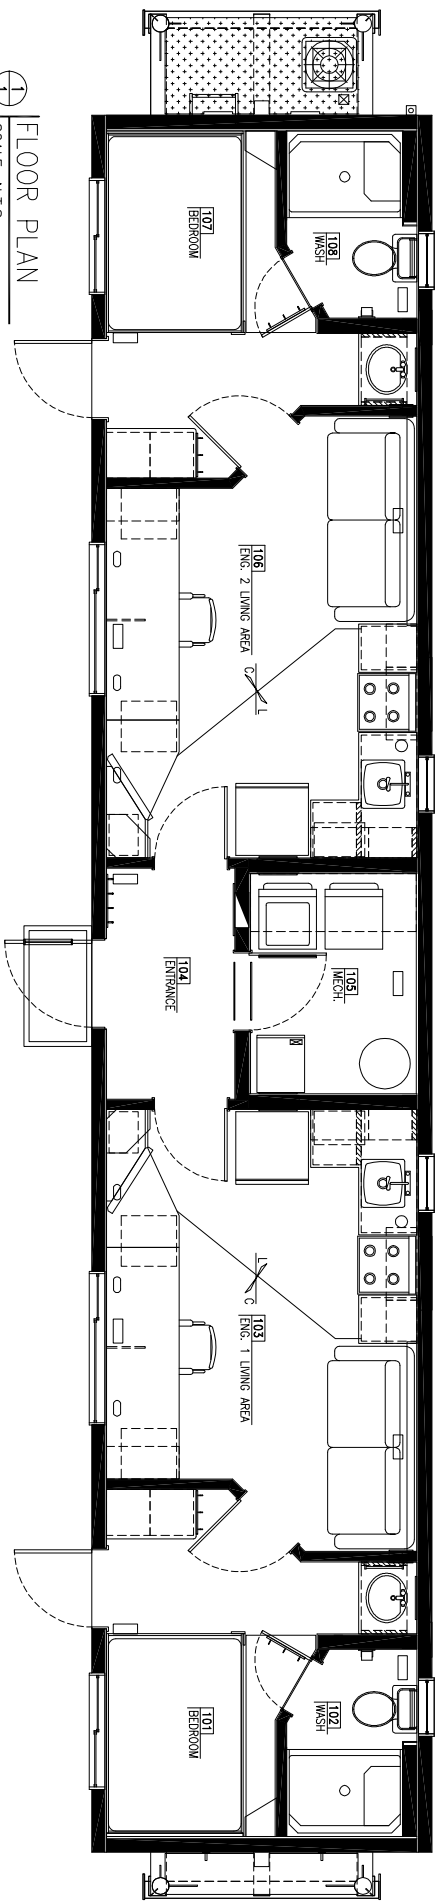

FLOOR PLAN
SCALE: N.T.S.

11' - 9" x 60' (skid) WELLSITE "ENG./ENG."

CLIENT: -
PROJECT NUMBER: PROTO
SERIAL NUMBER: NHAFF2375
MODEL NUMBER: 111260-S-WSEE
ENGINEERED REFERENCE #: SE(1260USWSEE)

FLOOR LIVE LOAD: 40 PSF
FLOOR DEAD LOAD: 10 PSF
ROOF DEAD LOAD: 40 PSF
ROOF LIVE LOAD: 12 PSF
WIND SPEED: 110 MPH (EXPOSURE C)
SEISMIC ZONE: D
SITE CLASS: RESIDENTIAL
BUILDING TYPE: TYPE V B
CONSTRUCTION: ONE STORY
NUMBER OF STORES: 11'-9" MAX. PER FLOOR
ALLOWABLE MOIST.

NOTES BY STATE:

 
NORTH DAKOTA:
1. 2009 INTERNATIONAL RESIDENTIAL CODE WITH AMENDMENTS.
2. 2009 INTERNATIONAL MECHANICAL CODE WITH AMENDMENTS.
3. 2009 INTERNATIONAL FUEL GAS CODE WITH AMENDMENTS.
4. 2011 NATIONAL ELECTRICAL CODE WITH AMENDMENTS.
5. 2009 UNIFORM PLUMBING CODE WITH STATE AMENDMENTS.
6. 2009 INTERNATIONAL ENERGY CONSERVATION CODE.
7. 1998 AND A1171 OR AMERICAN WITH DISABILITIES ACT
ACCESSIBILITY GUIDELINES (ADAAG).

MONTANA:
1. 2006 INTERNATIONAL RESIDENTIAL CODE.
2. 2009 UNIFORM PLUMBING CODE.
3. 2008 NATIONAL ELECTRICAL CODE.
4. 2009 INTERNATIONAL MECHANICAL CODE.
5. 2009 INTERNATIONAL FUEL GAS CODE.
6. 2009 INTERNATIONAL ENERGY CONSERVATION CODE.

WYOMING:
1. 2006 INTERNATIONAL RESIDENTIAL CODE
2. PLUMBING PER LOCAL JURISDICTION.
3. 2006 INTERNATIONAL FIRE CODE (INCLUDING APPENDIX D, E, F, AND G).
4. 2006 INTERNATIONAL MECHANICAL CODE.
5. 2006 INTERNATIONAL FUEL GAS CODE.
6. 2006 NATIONAL ELECTRICAL CODE.

COLORADO:
1. 2006 INTERNATIONAL RESIDENTIAL CODE.
2. INTERNATIONAL MECHANICAL CODE.
3. 2006 INTERNATIONAL PLUMBING CODE.
4. 2008 NATIONAL ELECTRICAL CODE.
5. 2006 INTERNATIONAL FUEL GAS CODE.
6. 2009 INTERNATIONAL ENERGY CONSERVATION CODE.

SOUTH DAKOTA:
1. 2006 INTERNATIONAL RESIDENTIAL CODE. **
2. 2009 INTERNATIONAL MECHANICAL CODE. **
3. 2011 NATIONAL ELECTRICAL CODE.
4. 2009 UNIFORM PLUMBING CODE.
** VERIFY WITH LOCAL BUILDING OFFICIAL




Copyrighted Material. No Reproduction of any kind of this document and its contents is permitted without the express written permission of nashua Structures Ltd.
©2011 nashua Structures Ltd.

CLIENT:

PLANT:

 TITLE SHEET



The Ultimate In Transportable Buildings 7957P6
504-1341
Address: 5001
Telephone: 780.955.7735 A Fax: 780.955.7851
Toll Free: 1.800.252.7990

DATE: APRIL 5, 2011
CWD FILE:
DRAWN: DLG
TEMPLATE FILE:

SALES PERSON: KN
CHECKED: KN
APPROVED: KN

DEPARTMENT: 1
13